
 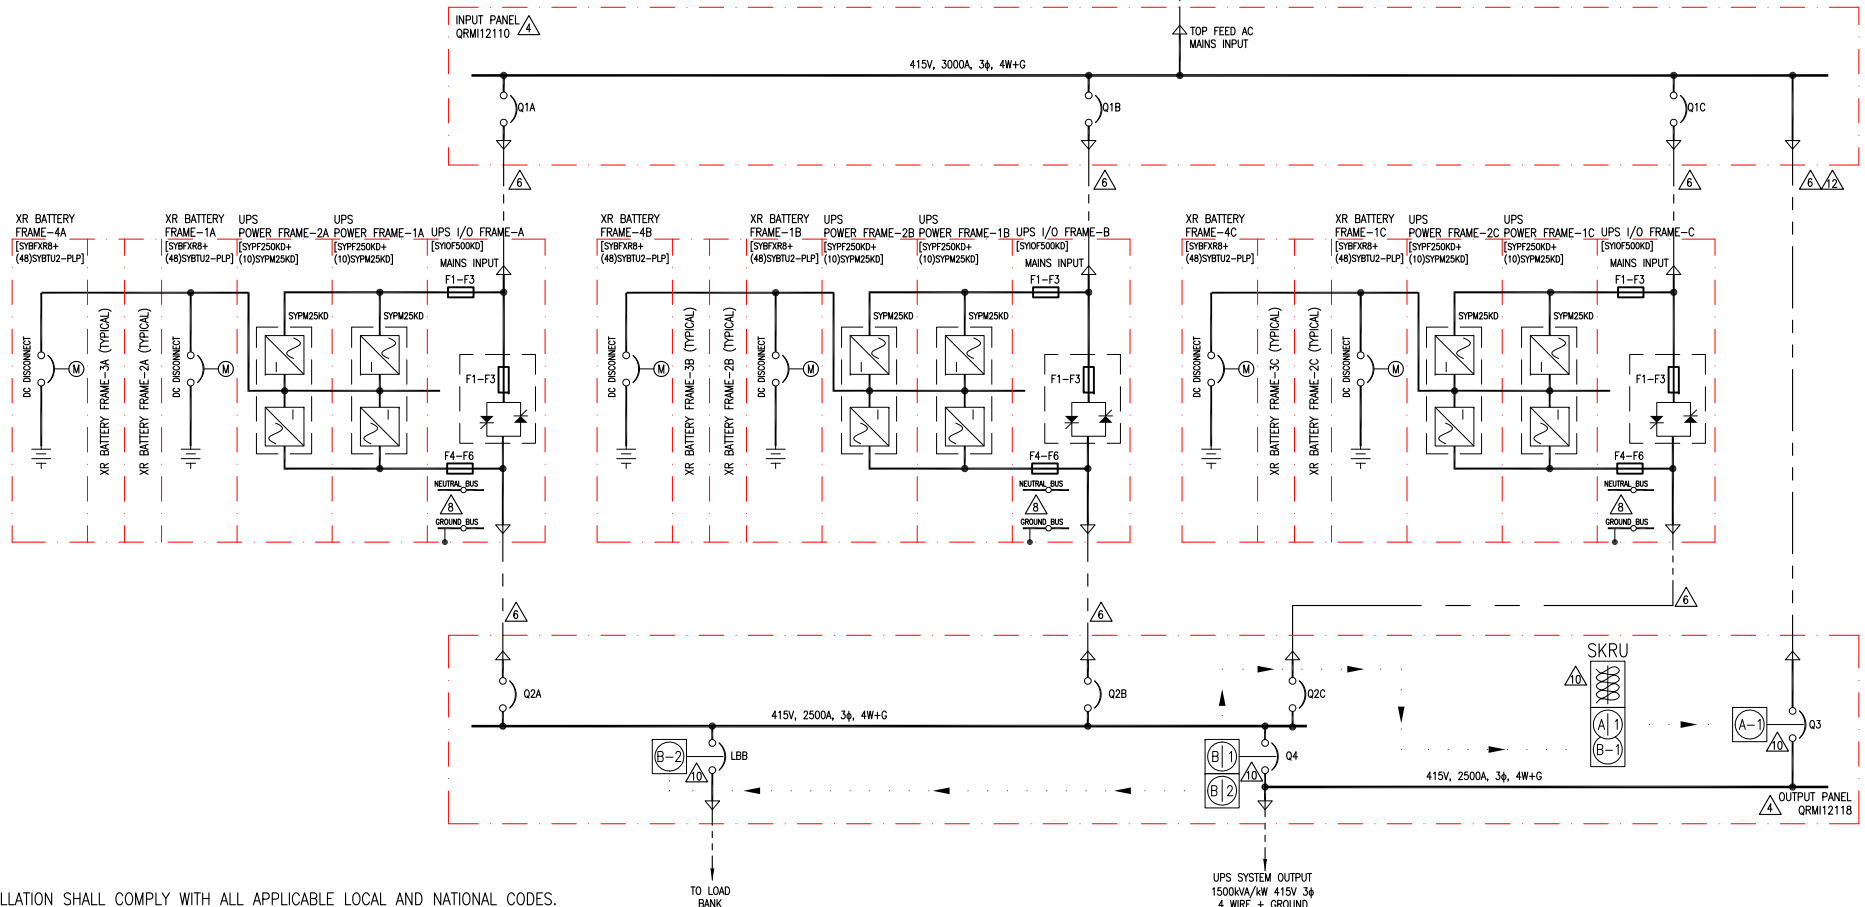


LEGEND:

----- AC CABLE - PROVIDED BY OTHERS



NOTES:

1. INSTALLATION SHALL COMPLY WITH ALL APPLICABLE LOCAL AND NATIONAL CODES.
2. PLEASE REFER TO PRODUCT MANUALS FOR ADDITIONAL DETAILS.
3. DRAWING DEPICTS POWER SYSTEM CONNECTIONS AND IS NOT REPRESENTATIVE OF PHYSICAL LAYOUT, PLEASE REFER TO MECHANICAL DRAWINGS FOR PHYSICAL LAYOUT.
- △ 4. MAXIMUM RATED SHORT CIRCUIT CURRENT IS 65kAIC, FOR UPS AND INPUT/OUTPUT PANELS.
- △ 5. AC UTILITY SOURCE SHALL BE 415VAC, 3φ, SOLIDLY GROUNDED WYE, 4 WIRE+GROUND (CONTACT Schneider Electric IF OTHER). SEE SHEET 4 FOR SITE PLANNING SUBMITTAL DATA.
- △ 6. AC CABLING SHALL BE 600V RATED, 4 WIRE+GROUND.
7. CABLE LUGS ARE NOT PROVIDED.
- △ 8. THE NEUTRAL TO GROUND SYSTEM BONDING JUMPER PROVIDED BY SCHNEIDER ELECTRIC SHALL NOT BE INSTALLED FOR 4 WIRE OUTPUT CONFIGURATION. SEE INSTALLATION MANUAL FOR DETAILS.
9. THIS DRAWING SHOWS MINIMUM NUMBER OF XR BATTERY FRAMES PER UPS. MAXIMUM (8) XR BATTERY FRAMES CAN BE BAYED TO EACH UPS. BAYING KIT IS SUPPLIED WITH THIS SOLUTION. XR BATTERY FRAME HAS MOTORIZED BREAKER.
- △ 10. KEY INTERLOCKS WITH SKRU, SCHEME 39, BETWEEN Q3 AND Q4, ARE OPTIONAL AND ARE NOT INCLUDED AS STANDARD WITH THE SYSTEM. (SCHEME 39 ADDER IS QCC67185) KEY INTERLOCKS WITH SKRU, SCHEME 29, BETWEEN LBB AND Q4, ARE OPTIONAL AND ARE NOT INCLUDED AS STANDARD WITH THE SYSTEM. (SCHEME 29 ADDER IS QCBA39274) LBB IS OPTIONAL AND IS NOT INCLUDED AS STANDARD WITH THE SYSTEM. (LBB ADDER IS QRM12158) INSTALLATION OF LBB AND KEY INTERLOCKS WITH SKRU IS STRONGLY RECOMMENDED.
11. CABLE LENGTHS FOR STATIC BYPASS INPUT AND OUTPUT SHALL BE SAME SUM TOTAL TO ENSURE CORRECT LOAD SHARING IN STATIC BYPASS OPERATION.
- △ 12. CABLE SIZE AND INSTALLATION SHALL COMPLY WITH NEC ART. 240.21. IF NOT, USE CABLES RATED SAME AS THE MIB FEEDER.

DEVICE RATING					
DEVICE	RATING	TYPE	MAKE	MODEL	ACCESSORIES
Q1A, Q1B, Q1C	1000A, 600V 100% RATED	MCCB, 3 POLE	Schneider Electric	PJP36100CU33AACBCKSKYP	3A/3B AUX CONT, BELL ALARM, 24VDC SHUNT TRIP, ML 5.0 TRIP UNIT
Q2A, Q2B, Q2C	700A, 600V 100% RATED	ICCB, 4 POLE	Schneider Electric	BL1AAV33B9CXBX000XA	8A/8B AUX CONT, BELL ALARM, 24VDC SHUNT TRIP, ML 5.0 TRIP UNIT
Q3	2500A, 600V 100% RATED	ICCB, 4 POLE	Schneider Electric	BL3GGB33A9CXFXXXXXA	8A/8B AUX CONT, BELL ALARM, 120VAC SHUNT TRIP, ML 5.0 TRIP UNIT
Q4	2500A, 600V 100% RATED	ICCB, 4 POLE	Schneider Electric	BL3GGB33A9CXBX000XA	8A/8B AUX CONT, BELL ALARM, 24VDC SHUNT TRIP, ML 5.0 TRIP UNIT
LBB	2500A, 600V 100% RATED	ICCB, 3 POLE	Schneider Electric	WL3GGB44A9CXBX000XA	8A/8B AUX CONT, BELL ALARM, 24VDC SHUNT TRIP, ML 5.0 TRIP UNIT
INVERTER FUSES F1-F3 / F4-F6	1250A, 700V	HIGH SPEED FUSE	BUSSMANN	170M6466	---
SSW FUSES F1-F3	1100A, 700V	HIGH SPEED FUSE	BUSSMANN	170M5167	---
DC DISCONNECT	400A, 600V DC	MCCB, 4 POLE	ABB	T5	1 AUX CONT, 24VDC, SHUNT TRIP, ACTUATOR

1500kVA/kW (500kW 3 MOD CAPACITY) TOP FEED SINGLE MAINS SINGLE INPUT TO UPS 4 WIRE OUTPUT CONFIGURATION

THIS DRAWING AND SPECIFICATIONS HEREIN ARE THE PROPERTY OF SCHNEIDER ELECTRIC AND SHALL NOT BE COPIED, REPRODUCED OR USED IN WHOLE OR IN PART, AS THE BASIS FOR THE MANUFACTURE OR SALE OF ITEMS WITHOUT WRITTEN PERMISSION FROM SCHNEIDER ELECTRIC. THIS DRAWING IS BASED UPON LATEST AVAILABLE INFORMATION AND IS SUBJECT TO CHANGE WITHOUT NOTICE.




TITLE: SYMMETRA PX
 INPUT: 415V 3φ, SINGLE MAINS, SINGLE INPUT TO UPS
 OUTPUT: 1500kVA/kW 415V 3φ
 500kW 3 MOD N TOP FEED W/LINE-UP BATTERIES
 SYSTEM ONE LINE DIAGRAM
 PROJECT: SUBMITTAL DRAWINGS SHEET 1 OF 7

DWG NO: SY500K1500TH1C3-4W-SD REV. 3
 DRAWN: BALMURKUN/V BUSH/R MILLER/S DINHA 02-DEC-14 PROJ ANGLE
 ENGINEER: C FLY 02-DEC-14 N.A.
 APPROVED: B SHERIDAN 02-DEC-14

LEGEND:

----- AC CABLE - PROVIDED BY OTHERS

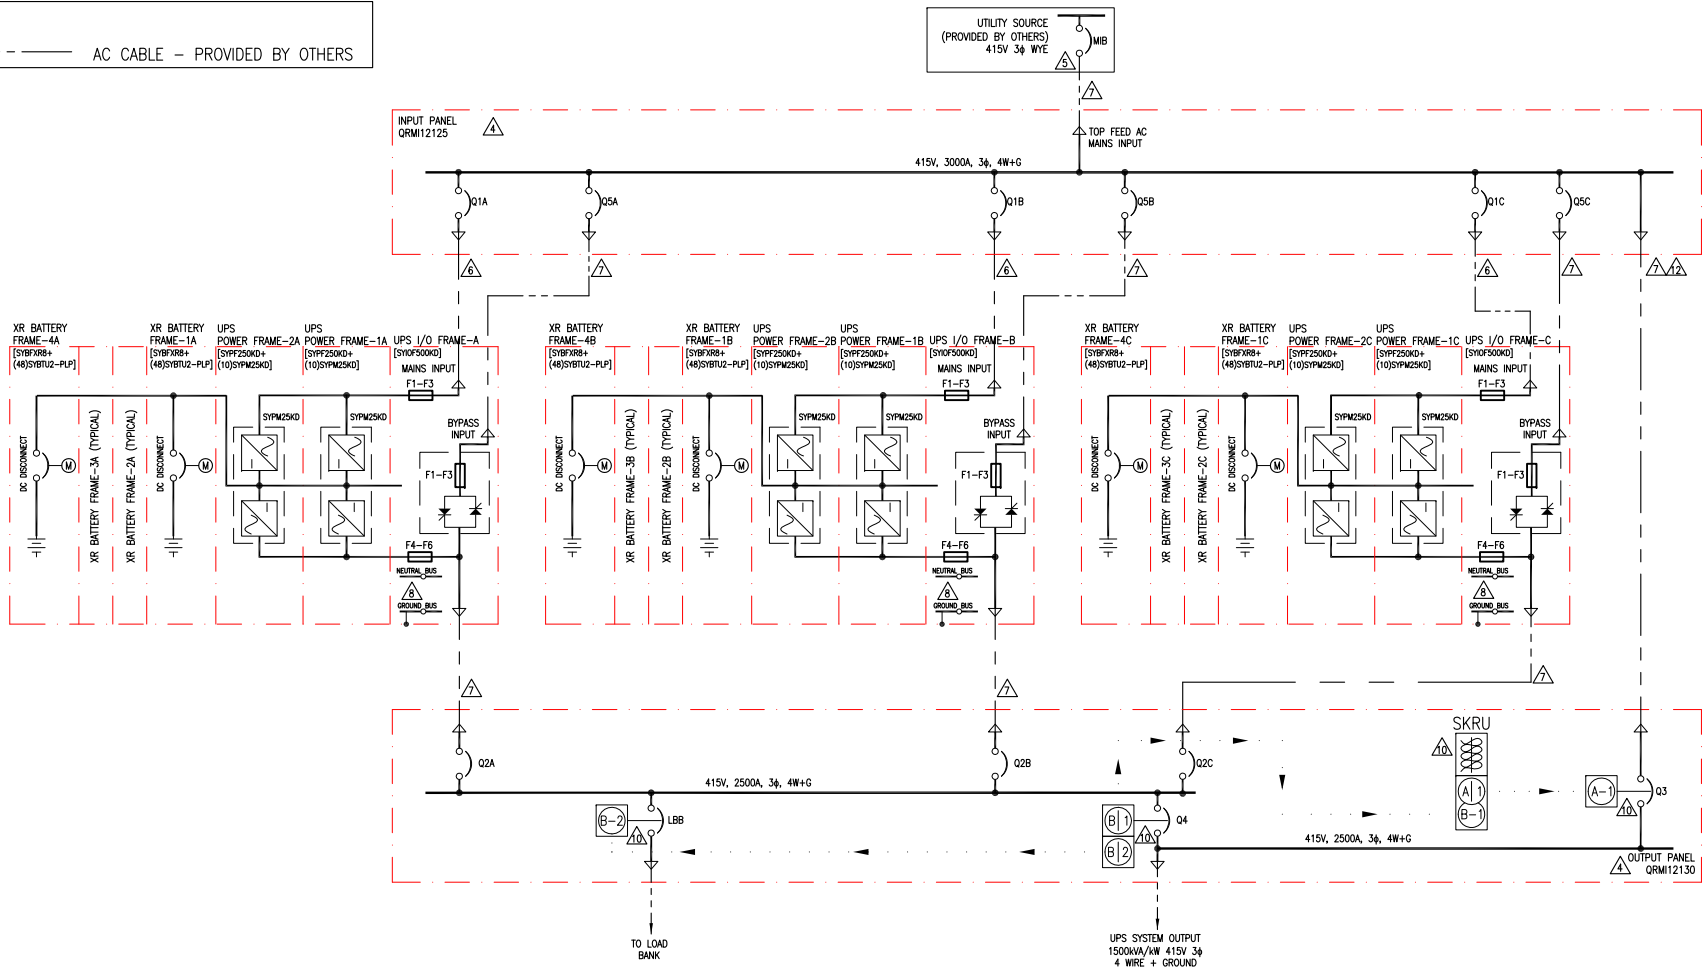

NOTES:

1. INSTALLATION SHALL COMPLY WITH ALL APPLICABLE LOCAL AND NATIONAL CODES.
2. PLEASE REFER TO PRODUCT MANUALS FOR ADDITIONAL DETAILS.
3. DRAWING DEPICTS POWER SYSTEM CONNECTIONS AND IS NOT REPRESENTATIVE OF PHYSICAL LAYOUT, PLEASE REFER TO MECHANICAL DRAWINGS FOR PHYSICAL LAYOUT.
- △ 4. MAXIMUM RATED SHORT CIRCUIT CURRENT IS 65kAIC, FOR UPS AND INPUT/OUTPUT PANELS.
- △ 5. AC UTILITY SOURCE SHALL BE 415VAC, 3Φ, SOLIDLY GROUNDING WYE, 4 WIRE+GROUND (CONTACT Schneider Electric IF OTHER). SEE SHEET 4 FOR SITE PLANNING SUBMITTAL DATA.
- △ 6. AC CABLING SHALL BE 600V RATED, 3 WIRE+GROUND.
- △ 7. AC CABLING SHALL BE 600V RATED, 4 WIRE+GROUND.
- △ 8. THE NEUTRAL TO GROUND SYSTEM BONDING JUMPER PROVIDED BY SCHNEIDER ELECTRIC SHALL NOT BE INSTALLED FOR 4 WIRE OUTPUT CONFIGURATION. SEE INSTALLATION MANUAL FOR DETAILS.
9. THIS DRAWING SHOWS MINIMUM NUMBER OF XR BATTERY FRAMES PER UPS. MAXIMUM (8) XR BATTERY FRAMES CAN BE BAYED TO EACH UPS. BAYING KIT IS SUPPLIED WITH THIS SOLUTION. XR BATTERY FRAME HAS MOTORIZED BREAKER.
- △ 10. KEY INTERLOCKS WITH SKRU, SCHEME 39, BETWEEN Q3 AND Q4, ARE OPTIONAL AND ARE NOT INCLUDED AS STANDARD WITH THE SYSTEM. (SCHEME 39 ADDER IS QCC67185) KEY INTERLOCKS WITH SKRU, SCHEME 29, BETWEEN LBB AND Q4, ARE OPTIONAL AND ARE NOT INCLUDED AS STANDARD WITH THE SYSTEM. (SCHEME 29 ADDER IS QCBA39274) LBB IS OPTIONAL AND IS NOT INCLUDED AS STANDARD WITH THE SYSTEM. (LBB ADDER IS QRM12163) INSTALLATION OF LBB AND KEY INTERLOCKS WITH SKRU IS STRONGLY RECOMMENDED.
11. CABLE LENGTHS FOR STATIC BYPASS INPUT AND OUTPUT SHALL BE SAME SUM TOTAL TO ENSURE CORRECT LOAD SHARING IN STATIC BYPASS OPERATION.
- △ 12. CABLE SIZE AND INSTALLATION SHALL COMPLY WITH NEC ART. 240.21. IF NOT, USE CABLES RATED SAME AS THE MIB FEEDER.
13. CABLE LUGS ARE NOT PROVIDED.

DEVICE RATING					
DEVICE	RATING	TYPE	MAKE	MODEL	ACCESSORIES
Q1A, Q1B, Q1C	1000A, 600V 100% RATED	MCCB, 3 POLE	Schneider Electric	PJP36100CU33ACBCSKYP	3A/3B AUX CONT, BELL ALARM, 24VDC SHUNT TRIP, ML 5.0 TRIP UNIT
Q2A, Q2B, Q2C	700A, 600V 100% RATED	ICCB, 4 POLE	Schneider Electric	BL1AAV33B9CXBX000XA	8A/8B AUX CONT, BELL ALARM, 24VDC SHUNT TRIP, ML 5.0 TRIP UNIT
Q3	2500A, 600V 100% RATED	ICCB, 4 POLE	Schneider Electric	BL3GGB33A9CXBX000XA	8A/8B AUX CONT, BELL ALARM, 120VAC SHUNT TRIP, ML 5.0 TRIP UNIT
Q4	2500A, 600V 100% RATED	ICCB, 4 POLE	Schneider Electric	BL3GGB33A9CXBX000XA	8A/8B AUX CONT, BELL ALARM, 24VDC SHUNT TRIP, ML 5.0 TRIP UNIT
Q5A, Q5B, Q5C	700A, 600V 100% RATED	MCCB, 3 POLE	Schneider Electric	PJP36080CU33BCSKYP	3A/3B AUX CONT, BELL ALARM, 24VDC SHUNT TRIP, ML 5.0 TRIP UNIT
LBB	2500A, 600V 100% RATED	ICCB, 3 POLE	Schneider Electric	WL3GGB44A9CXBX000XA	8A/8B AUX CONT, BELL ALARM, 24VDC SHUNT TRIP, ML 5.0 TRIP UNIT
INVERTER FUSES F1-F3 / F4-F6	1250A, 700V	HIGH SPEED FUSE	BUSSMANN	170M6466	--
SSW FUSES F1-F3	1100A, 700V	HIGH SPEED FUSE	BUSSMANN	170M5167	--
DC DISCONNECT	400A, 600V DC	MCCB, 4 POLE	ABB	T5	1 AUX CONT, 24VDC, SHUNT TRIP, ACTUATOR

1500kVA/kW (500kW 3 MOD CAPACITY) TOP FEED SINGLE MAINS, DUAL INPUT TO UPS 4 WIRE OUTPUT CONFIGURATION

THIS DRAWING AND SPECIFICATIONS HEREIN ARE THE PROPERTY OF SCHNEIDER ELECTRIC AND SHALL NOT BE COPIED, REPRODUCED OR USED IN WHOLE OR IN PART, AS THE BASIS FOR THE MANUFACTURE OR SALE OF ITEMS WITHOUT WRITTEN PERMISSION FROM SCHNEIDER ELECTRIC. THIS DRAWING IS BASED UPON LATEST AVAILABLE INFORMATION AND IS SUBJECT TO CHANGE WITHOUT NOTICE.




TITLE: SYMMETRA PX
 INPUT: 415V 3Φ, SINGLE MAINS, DUAL INPUT TO UPS
 OUTPUT: 1500kVA/kW 415V 3Φ
 500kW 3 MOD N TOP FEED W/LINE-UP BATTERIES
 SYSTEM ONE LINE DIAGRAM
 PROJECT: SUBMITTAL DRAWINGS SHEET 2 OF 7

DWG NO: SY500K1500TH1C3-4W-SD REV. 2
 DRAWN: BALMURICAN/V BUSH/R MILLER/S DINHA 02-DEC-14 PROJ ANGLE
 ENGINEER: C FLY 02-DEC-14 N.A.
 APPROVED: B SHERIDAN 02-DEC-14

LEGEND:

----- AC CABLE - PROVIDED BY OTHERS

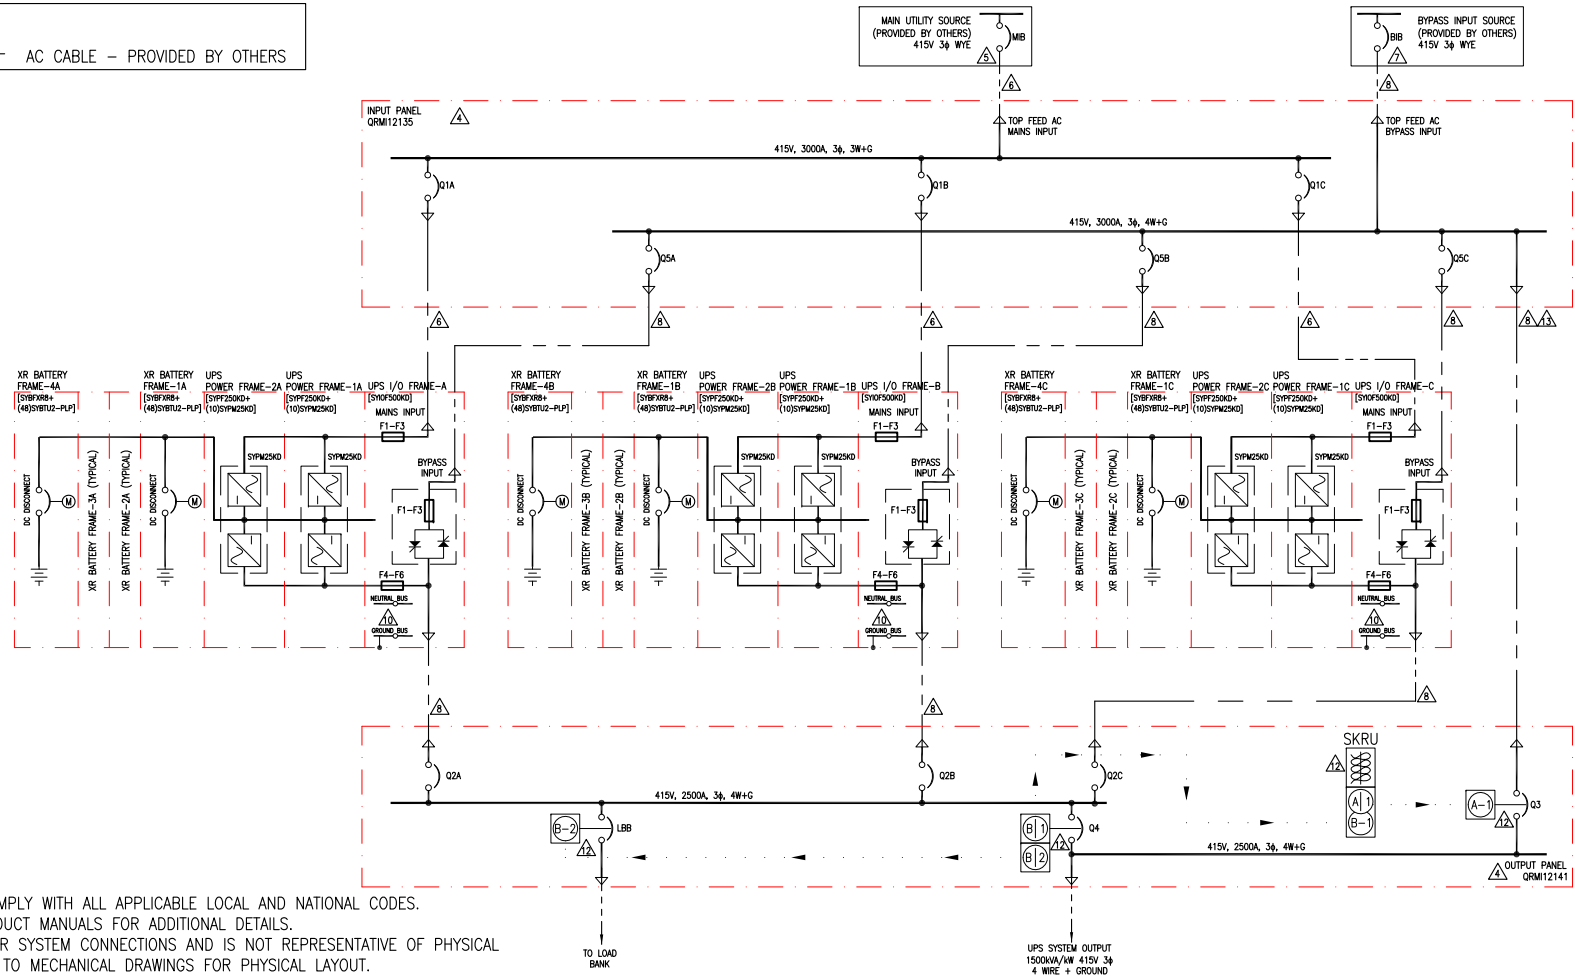

NOTES:

1. INSTALLATION SHALL COMPLY WITH ALL APPLICABLE LOCAL AND NATIONAL CODES.
2. PLEASE REFER TO PRODUCT MANUALS FOR ADDITIONAL DETAILS.
3. DRAWING DEPICTS POWER SYSTEM CONNECTIONS AND IS NOT REPRESENTATIVE OF PHYSICAL LAYOUT, PLEASE REFER TO MECHANICAL DRAWINGS FOR PHYSICAL LAYOUT.
4. MAXIMUM RATED SHORT CIRCUIT CURRENT IS 65KAIC, FOR UPS AND INPUT/OUTPUT PANELS.
5. AC MAIN UTILITY SOURCE SHALL BE 415VAC, 3φ, SOLIDLY GROUNDED WYE, 3 WIRE+GROUND (CONTACT Schneider Electric IF OTHER). SEE SHEET 4 FOR SITE PLANNING SUBMITTAL DATA.
6. AC CABLING SHALL BE 600V RATED, 3 WIRE+GROUND.
7. AC BYPASS UTILITY SOURCE SHALL BE 415VAC, 3φ, SOLIDLY GROUNDED WYE, 4 WIRE+GROUND (CONTACT Schneider Electric IF OTHER). SEE SHEET 4 FOR SITE PLANNING SUBMITTAL DATA.
8. AC CABLING SHALL BE 600V RATED, 4 WIRE+GROUND.
9. AC MAINS AND BYPASS COMING FROM SAME SOURCE SHALL BE 4 WIRE+GROUND.
10. THE NEUTRAL TO GROUND SYSTEM BONDING JUMPER PROVIDED BY Schneider Electric SHALL NOT BE INSTALLED FOR 4 WIRE OUTPUT CONFIGURATION. SEE INSTALLATION MANUAL FOR DETAILS.
11. THIS DRAWING SHOWS MINIMUM NUMBER OF XR BATTERY FRAMES PER UPS. MAXIMUM (8) XR BATTERY FRAMES CAN BE BAYED TO EACH UPS. BAYING KIT IS SUPPLIED WITH THIS SOLUTION. XR BATTERY FRAME HAS MOTORIZED BREAKER.
12. KEY INTERLOCKS WITH SKRU, SCHEME 39, BETWEEN Q3 AND Q4, ARE OPTIONAL AND ARE NOT INCLUDED AS STANDARD WITH THE SYSTEM. (SCHEME 39 ADDER IS QCC67185) KEY INTERLOCKS WITH SKRU, SCHEME 29, BETWEEN LBB AND Q4, ARE OPTIONAL AND ARE NOT INCLUDED AS STANDARD WITH THE SYSTEM. (SCHEME 29 ADDER IS QCBA39274) LBB IS OPTIONAL AND IS NOT INCLUDED AS STANDARD WITH THE SYSTEM. (LBB ADDER IS QRM12163) INSTALLATION OF LBB AND KEY INTERLOCKS WITH SKRU IS STRONGLY RECOMMENDED.
13. CABLE SIZE AND INSTALLATION SHALL COMPLY WITH NEC ART. 240.21. IF NOT, USE CABLES RATED SAME AS THE MIB FEEDER.
14. CABLE LENGTHS FOR STATIC BYPASS INPUT AND OUTPUT SHALL BE SAME SUM TOTAL TO ENSURE CORRECT LOAD SHARING IN STATIC BYPASS OPERATION.
15. CABLE LUGS ARE NOT PROVIDED.

DEVICE RATING					
DEVICE	RATING	TYPE	MAKE	MODEL	ACCESSORIES
Q1A, Q1B, Q1C	1000A, 600V 100% RATED	MCCB, 3 POLE	Schneider Electric	PJP36100CU33ACBCSKYP	3A/3B AUX CONT, BELL ALARM, 24VDC SHUNT TRIP, ML 5.0 TRIP UNIT
Q2A, Q2B, Q2C	700A, 600V 100% RATED	ICCB, 4 POLE	Schneider Electric	BL1AAV33B9CXBXXXXA	8A/8B AUX CONT, BELL ALARM, 24VDC SHUNT TRIP, ML 5.0 TRIP UNIT
Q3	2500A, 600V 100% RATED	ICCB, 4 POLE	Schneider Electric	BL3GGB33A9CXXFXXXXA	8A/8B AUX CONT, BELL ALARM, 120VAC SHUNT TRIP, ML 5.0 TRIP UNIT
Q4	2500A, 600V 100% RATED	ICCB, 4 POLE	Schneider Electric	BL3GGB33A9CXBXXXXA	8A/8B AUX CONT, BELL ALARM, 24VDC SHUNT TRIP, ML 5.0 TRIP UNIT
Q5A, Q5B, Q5C	700A, 600V 100% RATED	MCCB, 3 POLE	Schneider Electric	PJP36080CU33BCBCSKYP	3A/3B AUX CONT, BELL ALARM, 24VDC SHUNT TRIP, ML 5.0 TRIP UNIT
LBB	2500A, 600V 100% RATED	ICCB, 3 POLE	Schneider Electric	WL3GGB44A9CXBXXXXA	8A/8B AUX CONT, BELL ALARM, 24VDC SHUNT TRIP, ML 5.0 TRIP UNIT
INVERTER FUSES F1-F3 / F4-F6	1250A, 700V	HIGH SPEED FUSE	BUSSMANN	170M6466	--
SSW FUSES F1-F3	1100A, 700V	HIGH SPEED FUSE	BUSSMANN	170M5167	--
DC DISCONNECT	400A, 600V DC	MCCB, 4 POLE	ABB	T5	1 AUX CONT, 24VDC, SHUNT TRIP, ACTUATOR

1500kVA/kW (500kW 3 MOD CAPACITY) TOP FEED DUAL MAINS, DUAL INPUT TO UPS 4 WIRE OUTPUT CONFIGURATION

THIS DRAWING AND SPECIFICATIONS HEREIN ARE THE PROPERTY OF SCHNEIDER ELECTRIC AND SHALL NOT BE COPIED, REPRODUCED OR USED IN WHOLE OR IN PART, AS THE BASIS FOR THE MANUFACTURE OR SALE OF ITEMS WITHOUT WRITTEN PERMISSION FROM SCHNEIDER ELECTRIC. THIS DRAWING IS BASED UPON LATEST AVAILABLE INFORMATION AND IS SUBJECT TO CHANGE WITHOUT NOTICE.




TITLE: SYMMETRA PX
 INPUT: 415V 3φ, DUAL MAINS, DUAL INPUT TO UPS
 OUTPUT: 1500kVA/kW 415V 3φ
 500kW 3 MOD N TOP FEED W/LINE-UP BATTERIES
 SYSTEM ONE LINE DIAGRAM
 PROJECT: SUBMITTAL DRAWINGS SHEET 3 OF 7

DWG NO: SY500K1500TH2C3-4W-SD REV. 2
 DRAWN: BALMURJAN/V BUSH/R MILLER/S DINHA 02-DEC-14
 ENGINEER: C FLY 02-DEC-14
 APPROVED: B SHERIDAN 02-DEC-14
 PROJ ANGLE N.A.

LEGEND:

----- AC CABLE - PROVIDED BY OTHERS

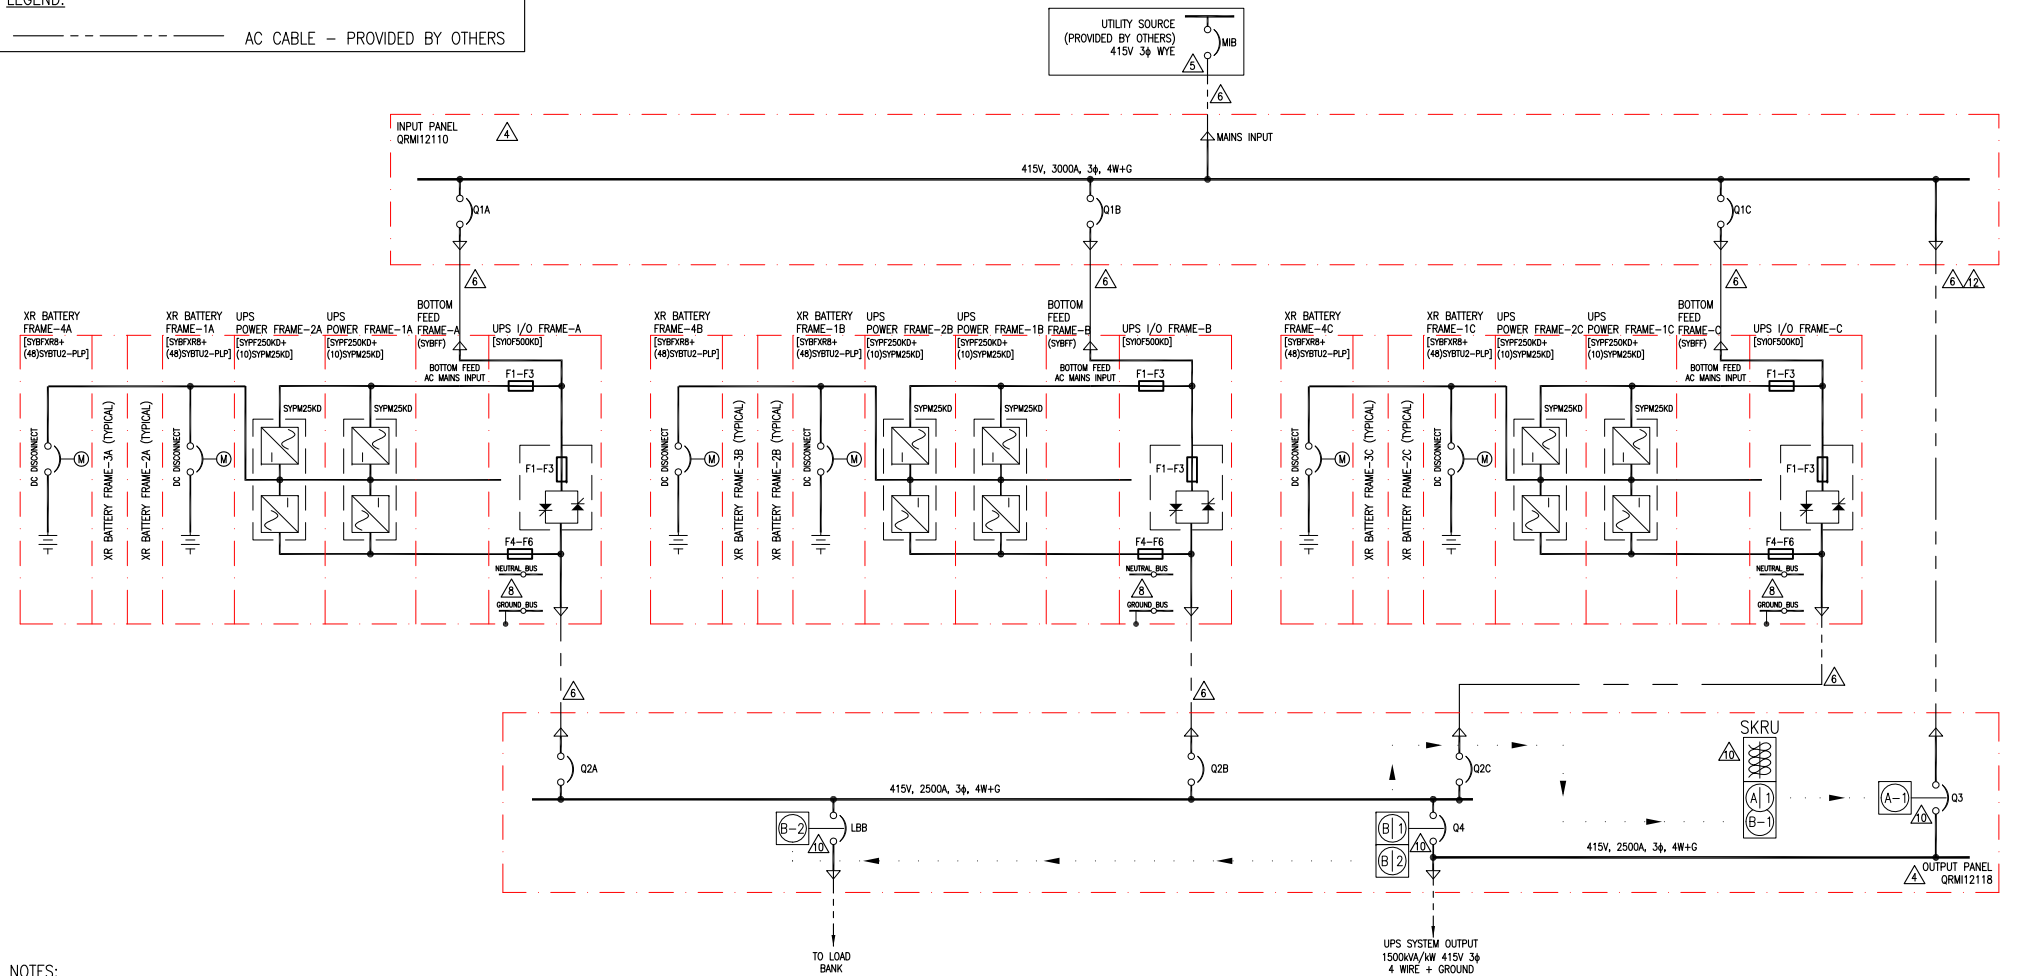

NOTES:

1. INSTALLATION SHALL COMPLY WITH ALL APPLICABLE LOCAL AND NATIONAL CODES.
2. PLEASE REFER TO PRODUCT MANUALS FOR ADDITIONAL DETAILS.
3. DRAWING DEPICTS POWER SYSTEM CONNECTIONS AND IS NOT REPRESENTATIVE OF PHYSICAL LAYOUT, PLEASE REFER TO MECHANICAL DRAWINGS FOR PHYSICAL LAYOUT.
- △ 4. MAXIMUM RATED SHORT CIRCUIT CURRENT IS 65kAIC, FOR UPS AND INPUT/OUTPUT PANELS.
- △ 5. AC UTILITY SOURCE SHALL BE 415VAC, 3φ, SOLIDLY GROUNDING WYE, 4 WIRE+GROUND (CONTACT Schneider Electric IF OTHER). SEE SHEET 4 FOR SITE PLANNING SUBMITTAL DATA.
- △ 6. AC CABLING SHALL BE 600V RATED, 4 WIRE+GROUND.
7. CABLE LUGS ARE NOT PROVIDED.
- △ 8. THE NEUTRAL TO GROUND SYSTEM BONDING JUMPER PROVIDED BY SCHNEIDER ELECTRIC SHALL NOT BE INSTALLED FOR 4 WIRE OUTPUT CONFIGURATION. SEE INSTALLATION MANUAL FOR DETAILS.
9. THIS DRAWING SHOWS MINIMUM NUMBER OF XR BATTERY FRAMES PER UPS. MAXIMUM (8) XR BATTERY FRAMES CAN BE BAYED TO EACH UPS. BAYING KIT IS SUPPLIED WITH THIS SOLUTION. XR BATTERY FRAME HAS MOTORIZED BREAKER.
- △ 10. KEY INTERLOCKS WITH SKRU, SCHEME 39, BETWEEN Q3 AND Q4, ARE OPTIONAL AND ARE NOT INCLUDED AS STANDARD WITH THE SYSTEM. (SCHEME 39 ADDER IS QCC67185) KEY INTERLOCKS WITH SKRU, SCHEME 29, BETWEEN LBB AND Q4, ARE OPTIONAL AND ARE NOT INCLUDED AS STANDARD WITH THE SYSTEM. (SCHEME 29 ADDER IS QCBA39274) LBB IS OPTIONAL AND IS NOT INCLUDED AS STANDARD WITH THE SYSTEM. (LBB ADDER IS QRMI12158) INSTALLATION OF LBB AND KEY INTERLOCKS WITH SKRU IS STRONGLY RECOMMENDED.
11. CABLE LENGTHS FOR STATIC BYPASS INPUT AND OUTPUT SHALL BE SAME SUM TOTAL TO ENSURE CORRECT LOAD SHARING IN STATIC BYPASS OPERATION.
- △ 12. CABLE SIZE AND INSTALLATION SHALL COMPLY WITH NEC ART. 240.21. IF NOT, USE CABLES RATED SAME AS THE MIB FEEDER.

DEVICE RATING					
DEVICE	RATING	TYPE	MAKE	MODEL	ACCESSORIES
Q1A, Q1B, Q1C	1000A, 600V 100% RATED	MCCB, 3 POLE	Schneider Electric	PJP36100CJ33ACBCSKYP	3A/3B AUX CONT, BELL ALARM, 24VDC SHUNT TRIP, ML 5.0 TRIP UNIT
Q2A, Q2B, Q2C	700A, 600V 100% RATED	ICCB, 4 POLE	Schneider Electric	BL1AAV33B9CXBX0000A	8A/8B AUX CONT, BELL ALARM, 24VDC SHUNT TRIP, ML 5.0 TRIP UNIT
Q3	2500A, 600V 100% RATED	ICCB, 4 POLE	Schneider Electric	BL3GGB33A9CXF00000A	8A/8B AUX CONT, BELL ALARM, 120VAC SHUNT TRIP, ML 5.0 TRIP UNIT
Q4	2500A, 600V 100% RATED	ICCB, 4 POLE	Schneider Electric	BL3GGB33A9CXBX0000A	8A/8B AUX CONT, BELL ALARM, 24VDC SHUNT TRIP, ML 5.0 TRIP UNIT
LBB	2500A, 600V 100% RATED	ICCB, 3 POLE	Schneider Electric	WL3GGB44A9CXBX0000A	8A/8B AUX CONT, BELL ALARM, 24VDC SHUNT TRIP, ML 5.0 TRIP UNIT
INVERTER FUSES F1-F3 / F4-F6	1250A, 700V	HIGH SPEED FUSE	BUSSMANN	170M6466	--
SSW FUSES F1-F3	1100A, 700V	HIGH SPEED FUSE	BUSSMANN	170M5167	--
DC DISCONNECT	400A, 600V DC	MCCB, 4 POLE	ABB	T5	1 AUX CONT, 24VDC, SHUNT TRIP, ACTUATOR

1500kVA/kW (500kW 3 MOD CAPACITY) BOTTOM FEED SINGLE MAINS SINGLE INPUT TO UPS 4 WIRE OUTPUT CONFIGURATION

THIS DRAWING AND SPECIFICATIONS HEREIN ARE THE PROPERTY OF SCHNEIDER ELECTRIC AND SHALL NOT BE COPIED, REPRODUCED OR USED IN WHOLE OR IN PART, AS THE BASIS FOR THE MANUFACTURE OR SALE OF ITEMS WITHOUT WRITTEN PERMISSION FROM SCHNEIDER ELECTRIC. THIS DRAWING IS BASED UPON LATEST AVAILABLE INFORMATION AND IS SUBJECT TO CHANGE WITHOUT NOTICE.




TITLE: SYMMETRA PX
 INPUT: 415V 3φ, SINGLE MAINS, SINGLE INPUT TO UPS
 OUTPUT: 1500kVA/kW 415V 3φ
 500kW 3 MOD N BOTTOM FEED W/LINE-UP BATTERIES
 SYSTEM ONE LINE DIAGRAM
 PROJECT: SUBMITTAL DRAWINGS SHEET 4 OF 7

DWG NO: SY500K1500BH1C3-4W-SD
 DRAWN: BALAMURUGAN/S CUNHA
 ENGINEER: C FLY
 APPROVED: B SHERIDAN

REV. 2
 02-DEC-14
 02-DEC-14
 PROJ ANGLE
 N.A.

LEGEND:

----- AC CABLE - PROVIDED BY OTHERS

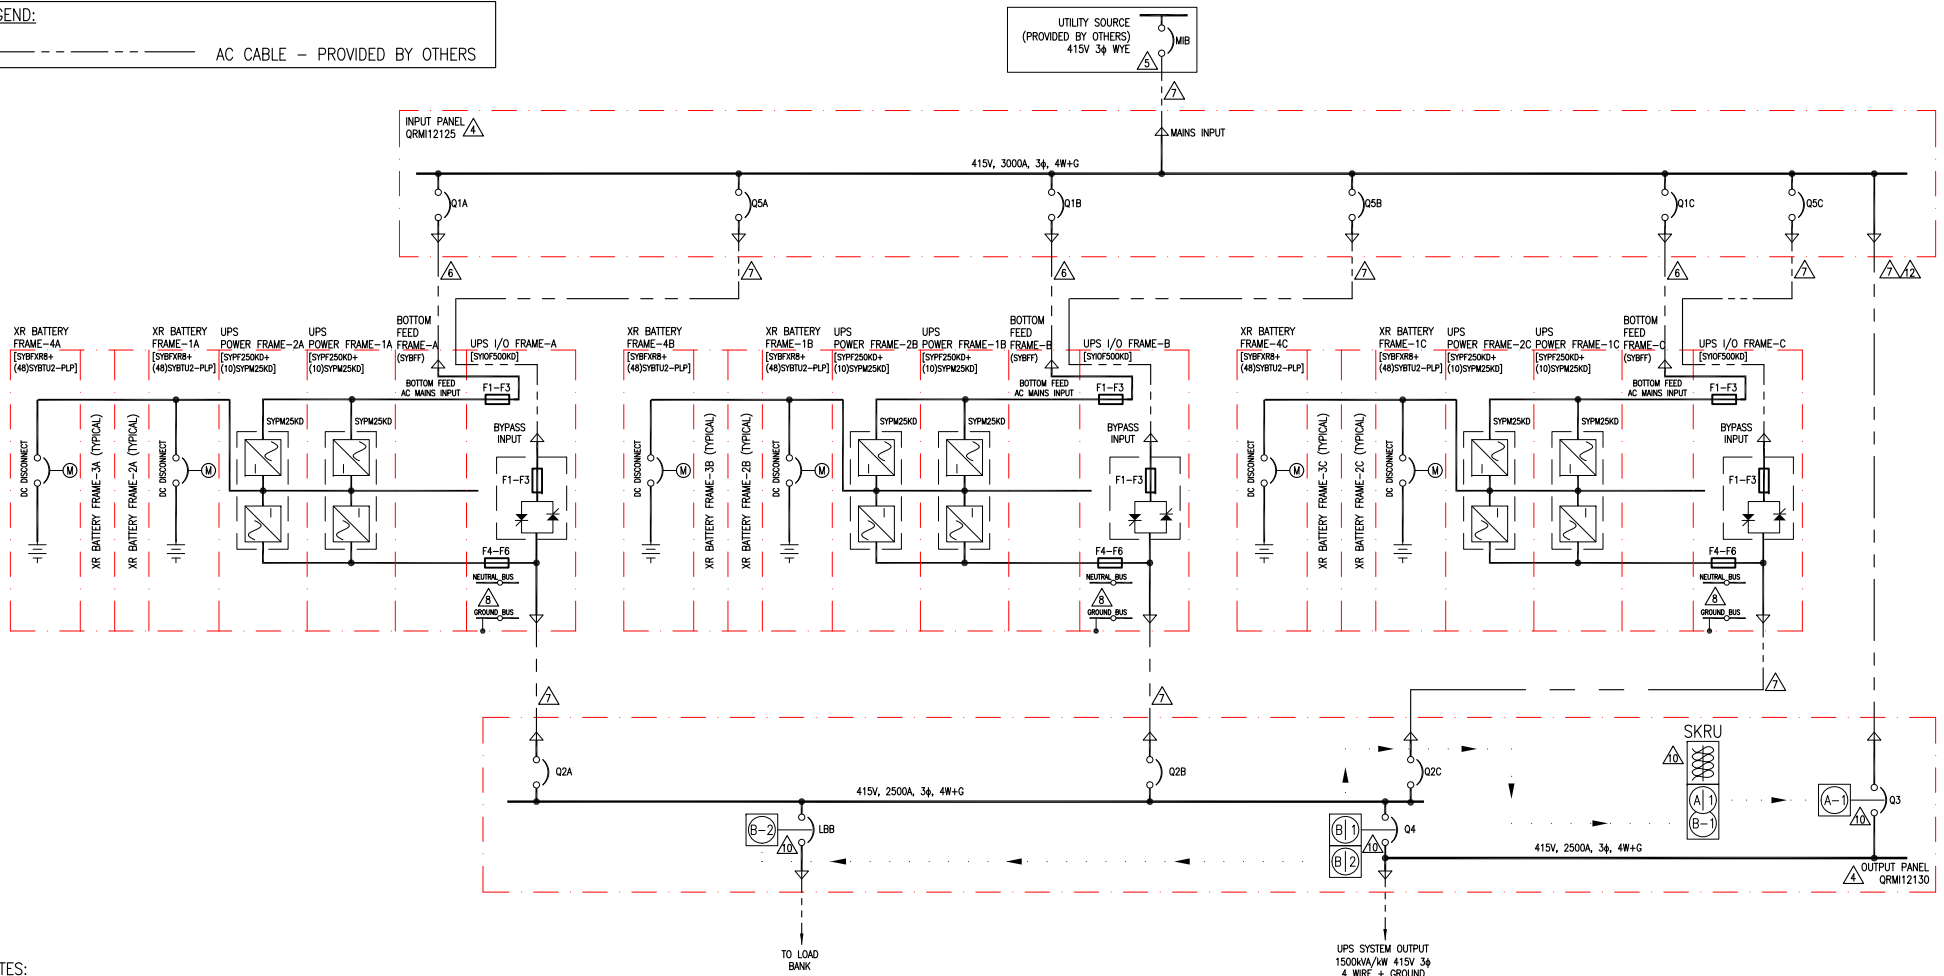

NOTES:

1. INSTALLATION SHALL COMPLY WITH ALL APPLICABLE LOCAL AND NATIONAL CODES.
2. PLEASE REFER TO PRODUCT MANUALS FOR ADDITIONAL DETAILS.
3. DRAWING DEPICTS POWER SYSTEM CONNECTIONS AND IS NOT REPRESENTATIVE OF PHYSICAL LAYOUT, PLEASE REFER TO MECHANICAL DRAWINGS FOR PHYSICAL LAYOUT.
4. MAXIMUM RATED SHORT CIRCUIT CURRENT IS 65kAIC, FOR UPS AND INPUT/OUTPUT PANELS.
5. AC UTILITY SOURCE SHALL BE 415VAC, 3φ, SOLIDLY GROUNDED WYE, 4 WIRE+GROUND (CONTACT Schneider Electric IF OTHER). SEE SHEET 4 FOR SITE PLANNING SUBMITTAL DATA.
6. AC CABLING SHALL BE 600V RATED, 3 WIRE+GROUND.
7. AC CABLING SHALL BE 600V RATED, 4 WIRE+GROUND.
8. THE NEUTRAL TO GROUND SYSTEM BONDING JUMPER PROVIDED BY SCHNEIDER ELECTRIC SHALL NOT BE INSTALLED FOR 4 WIRE OUTPUT CONFIGURATION. SEE INSTALLATION MANUAL FOR DETAILS.
9. THIS DRAWING SHOWS MINIMUM NUMBER OF XR BATTERY FRAMES PER UPS. MAXIMUM (8) XR BATTERY FRAMES CAN BE BAYED TO EACH UPS. BAYING KIT IS SUPPLIED WITH THIS SOLUTION. XR BATTERY FRAME HAS MOTORIZED BREAKER.
10. KEY INTERLOCKS WITH SKRU, SCHEME 39, BETWEEN Q3 AND Q4, ARE OPTIONAL AND ARE NOT INCLUDED AS STANDARD WITH THE SYSTEM. (SCHEME 39 ADDER IS QCC67185) KEY INTERLOCKS WITH SKRU, SCHEME 29, BETWEEN LBB AND Q4, ARE OPTIONAL AND ARE NOT INCLUDED AS STANDARD WITH THE SYSTEM. (SCHEME 29 ADDER IS QCBA39274) LBB IS OPTIONAL AND IS NOT INCLUDED AS STANDARD WITH THE SYSTEM. (LBB ADDER IS QRM12163) INSTALLATION OF LBB AND KEY INTERLOCKS WITH SKRU IS STRONGLY RECOMMENDED.
11. CABLE LENGTHS FOR STATIC BYPASS INPUT AND OUTPUT SHALL BE SAME SUM TOTAL TO ENSURE CORRECT LOAD SHARING IN STATIC BYPASS OPERATION.
12. CABLE SIZE AND INSTALLATION SHALL COMPLY WITH NEC ART. 240.21. IF NOT, USE CABLES RATED SAME AS THE MIB FEEDER.
13. CABLE LUGS ARE NOT PROVIDED.

1500kVA/kW (500kW 3 MOD CAPACITY) BOTTOM FEED SINGLE MAINS, DUAL INPUT TO UPS 4 WIRE OUTPUT CONFIGURATION

DEVICE RATING					
DEVICE	RATING	TYPE	MAKE	MODEL	ACCESSORIES
Q1A, Q1B, Q1C	1000A, 600V 100% RATED	MCCB, 3 POLE	Schneider Electric	PJP36100CU33AACBCKSKYP	3A/3B AUX CONT, BELL ALARM, 24VDC SHUNT TRIP, ML 5.0 TRIP UNIT
Q2A, Q2B, Q2C	700A, 600V 100% RATED	ICCB, 4 POLE	Schneider Electric	BL1AAV33B9CXBXXXXA	8A/8B AUX CONT, BELL ALARM, 24VDC SHUNT TRIP, ML 5.0 TRIP UNIT
Q3	2500A, 600V 100% RATED	ICCB, 4 POLE	Schneider Electric	BL3GGB33A9CXFXXXXXA	8A/8B AUX CONT, BELL ALARM, 120VAC SHUNT TRIP, ML 5.0 TRIP UNIT
Q4	2500A, 600V 100% RATED	ICCB, 4 POLE	Schneider Electric	BL3GGB33A9CXBXXXXA	8A/8B AUX CONT, BELL ALARM, 24VDC SHUNT TRIP, ML 5.0 TRIP UNIT
Q5A, Q5B, Q5C	700A, 600V 100% RATED	MCCB, 3 POLE	Schneider Electric	PJP36080CU33BCKSKYP	3A/3B AUX CONT, BELL ALARM, 24VDC SHUNT TRIP, ML 5.0 TRIP UNIT
LBB	2500A, 600V 100% RATED	ICCB, 3 POLE	Schneider Electric	WL3GGB44A9CXBXXXXA	8A/8B AUX CONT, BELL ALARM, 24VDC SHUNT TRIP, ML 5.0 TRIP UNIT
INVERTER FUSES F1-F3 / F4-F6	1250A, 700V	HIGH SPEED FUSE	BUSSMANN	170M6466	--
SSW FUSES F1-F3	1100A, 700V	HIGH SPEED FUSE	BUSSMANN	170M5167	--
DC DISCONNECT	400A, 600V DC	MCCB, 4 POLE	ABB	T5	1 AUX CONT, 24VDC, SHUNT TRIP, ACTUATOR

THIS DRAWING AND SPECIFICATIONS HEREIN ARE THE PROPERTY OF SCHNEIDER ELECTRIC AND SHALL NOT BE COPIED, REPRODUCED OR USED IN WHOLE OR IN PART, AS THE BASIS FOR THE MANUFACTURE OR SALE OF ITEMS WITHOUT WRITTEN PERMISSION FROM SCHNEIDER ELECTRIC. THIS DRAWING IS BASED UPON LATEST AVAILABLE INFORMATION AND IS SUBJECT TO CHANGE WITHOUT NOTICE.




TITLE: SYMMETRA PX
 INPUT: 415V 3φ, SINGLE MAINS, DUAL INPUT TO UPS
 OUTPUT: 1500kVA/kW 415V 3φ
 500kW 3 MOD N BOTTOM FEED W/LINE-UP BATTERIES
 SYSTEM ONE LINE DIAGRAM
 PROJECT: SUBMITTAL DRAWINGS SHEET 5 OF 7

DWG NO: SY500K1500BH1C3-4W-SD
 DRAWN: BALAMURUGAN/S CUNHA
 ENGINEER: C FLY
 APPROVED: B SHERIDAN
 02-DEC-14
 02-DEC-14
 PROJ ANGLE N.A.

REV. 2

LEGEND:

----- AC CABLE - PROVIDED BY OTHERS

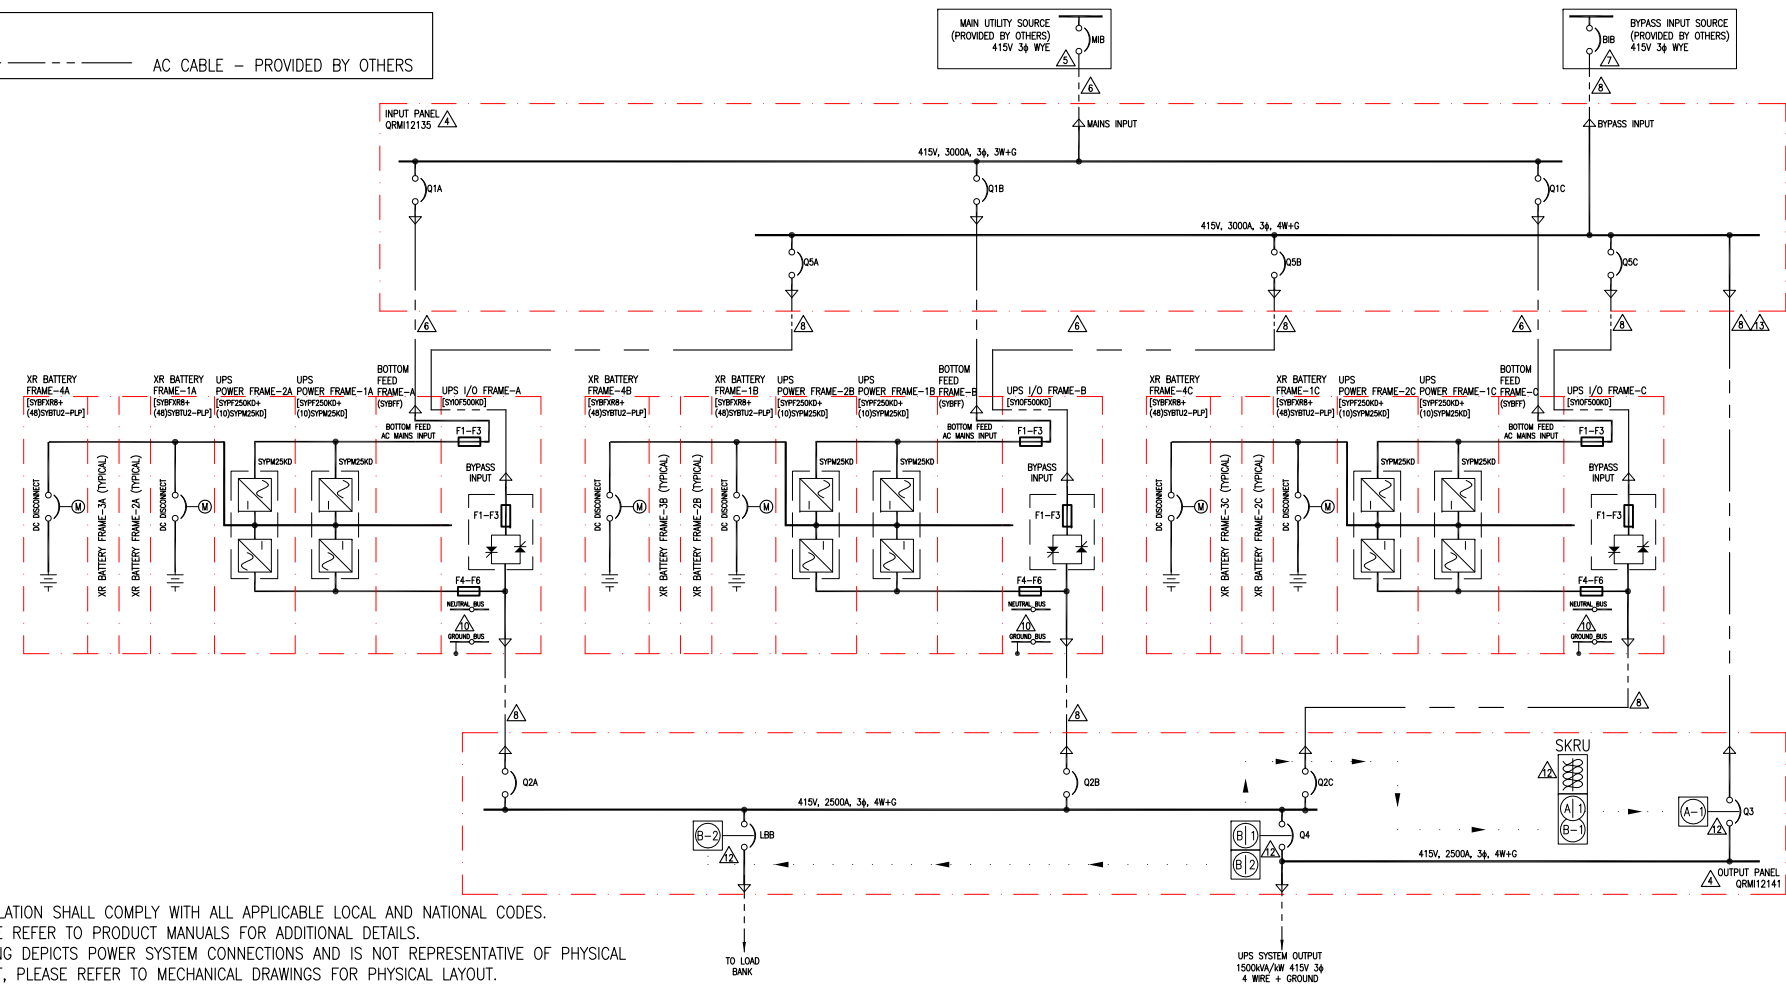

NOTES:

1. INSTALLATION SHALL COMPLY WITH ALL APPLICABLE LOCAL AND NATIONAL CODES.
2. PLEASE REFER TO PRODUCT MANUALS FOR ADDITIONAL DETAILS.
3. DRAWING DEPICTS POWER SYSTEM CONNECTIONS AND IS NOT REPRESENTATIVE OF PHYSICAL LAYOUT, PLEASE REFER TO MECHANICAL DRAWINGS FOR PHYSICAL LAYOUT.
4. MAXIMUM RATED SHORT CIRCUIT CURRENT IS 65KAIC, FOR UPS AND INPUT/OUTPUT PANELS.
5. AC MAIN UTILITY SOURCE SHALL BE 415VAC, 3φ, SOLIDLY GROUNDED WYE, 3 WIRE+GROUND (CONTACT Schneider Electric IF OTHER). SEE SHEET 4 FOR SITE PLANNING SUBMITTAL DATA.
6. AC CABLING SHALL BE 600V RATED, 3 WIRE+GROUND.
7. AC BYPASS UTILITY SOURCE SHALL BE 415VAC, 3φ, SOLIDLY GROUNDED WYE, 4 WIRE+GROUND (CONTACT Schneider Electric IF OTHER). SEE SHEET 4 FOR SITE PLANNING SUBMITTAL DATA.
8. AC CABLING SHALL BE 600V RATED, 4 WIRE+GROUND.
9. AC MAINS AND BYPASS COMING FROM SAME SOURCE SHALL BE 4 WIRE+GROUND.
10. THE NEUTRAL TO GROUND SYSTEM BONDING JUMPER PROVIDED BY Schneider Electric SHALL NOT BE INSTALLED FOR 4 WIRE OUTPUT CONFIGURATION. SEE INSTALLATION MANUAL FOR DETAILS.
11. THIS DRAWING SHOWS MINIMUM NUMBER OF XR BATTERY FRAMES PER UPS. MAXIMUM (8) XR BATTERY FRAMES CAN BE BAYED TO EACH UPS. BAYING KIT IS SUPPLIED WITH THIS SOLUTION. XR BATTERY FRAME HAS MOTORIZED BREAKER.
12. KEY INTERLOCKS WITH SKRU, SCHEME 39, BETWEEN Q3 AND Q4, ARE OPTIONAL AND ARE NOT INCLUDED AS STANDARD WITH THE SYSTEM. (SCHEME 39 ADDER IS QCC67185) KEY INTERLOCKS WITH SKRU, SCHEME 29, BETWEEN LBB AND Q4, ARE OPTIONAL AND ARE NOT INCLUDED AS STANDARD WITH THE SYSTEM. (SCHEME 29 ADDER IS QCBA39274) LBB IS OPTIONAL AND IS NOT INCLUDED AS STANDARD WITH THE SYSTEM. (LBB ADDER IS QRM12163) INSTALLATION OF LBB AND KEY INTERLOCKS WITH SKRU IS STRONGLY RECOMMENDED.
13. CABLE SIZE AND INSTALLATION SHALL COMPLY WITH NEC ART. 240.21. IF NOT, USE CABLES RATED SAME AS THE MIB FEEDER.
14. CABLE LENGTHS FOR STATIC BYPASS INPUT AND OUTPUT SHALL BE SAME SUM TOTAL TO ENSURE CORRECT LOAD SHARING IN STATIC BYPASS OPERATION.
15. CABLE LUGS ARE NOT PROVIDED.

DEVICE RATING

DEVICE	RATING	TYPE	MAKE	MODEL	ACCESSORIES
Q1A, Q1B, Q1C	1000A, 600V 100% RATED	MCCB, 3 POLE	Schneider Electric	PJP36100CU33AACBCSKYP	3A/3B AUX CONT, BELL ALARM, 24VDC SHUNT TRIP, ML 5.0 TRIP UNIT
Q2A, Q2B, Q2C	700A, 600V 100% RATED	ICCB, 4 POLE	Schneider Electric	BL1AAV33B9CXBX0000A	8A/8B AUX CONT, BELL ALARM, 24VDC SHUNT TRIP, ML 5.0 TRIP UNIT
Q3	2500A, 600V 100% RATED	ICCB, 4 POLE	Schneider Electric	BL3GGB33A9CXFX0000A	8A/8B AUX CONT, BELL ALARM, 120VAC SHUNT TRIP, ML 5.0 TRIP UNIT
Q4	2500A, 600V 100% RATED	ICCB, 4 POLE	Schneider Electric	BL3GGB33A9CXBX0000A	8A/8B AUX CONT, BELL ALARM, 24VDC SHUNT TRIP, ML 5.0 TRIP UNIT
Q5A, Q5B, Q5C	700A, 600V 100% RATED	MCCB, 3 POLE	Schneider Electric	PJP36080CU33BCBCSKYP	3A/3B AUX CONT, BELL ALARM, 24VDC SHUNT TRIP, ML 5.0 TRIP UNIT
LBB	2500A, 600V 100% RATED	ICCB, 3 POLE	Schneider Electric	WL3GGB44A9CXBX0000A	8A/8B AUX CONT, BELL ALARM, 24VDC SHUNT TRIP, ML 5.0 TRIP UNIT
INVERTER FUSES F1-F3 / F4-F6	1250A, 700V	HIGH SPEED FUSE	BUSSMANN	170M6466	--
SSW FUSES F1-F3	1100A, 700V	HIGH SPEED FUSE	BUSSMANN	170M5167	--
DC DISCONNECT	400A, 600V DC	MCCB, 4 POLE	ABB	T5	1 AUX CONT, 24VDC, SHUNT TRIP, ACTUATOR

1500kVA/kW (500kW 3 MOD CAPACITY) BOTTOM FEED DUAL MAINS, DUAL INPUT TO UPS 4 WIRE OUTPUT CONFIGURATION

THIS DRAWING AND SPECIFICATIONS HEREIN ARE THE PROPERTY OF SCHNEIDER ELECTRIC AND SHALL NOT BE COPIED, REPRODUCED OR USED IN WHOLE OR IN PART, AS THE BASIS FOR THE MANUFACTURE OR SALE OF ITEMS WITHOUT WRITTEN PERMISSION FROM SCHNEIDER ELECTRIC. THIS DRAWING IS BASED UPON LATEST AVAILABLE INFORMATION AND IS SUBJECT TO CHANGE WITHOUT NOTICE.



TITLE: SYMMETRA PX INPUT: 415V 3φ, DUAL MAINS, DUAL INPUT TO UPS OUTPUT: 1500kVA/kW 415V 3φ 500kW 3 MOD N BOTTOM FEED W/LINE-UP BATTERIES SYSTEM ONE LINE DIAGRAM	DWG NO: SY500K1500BH2C3-4W-SD	REV: 2
PROJECT: SUBMITTAL DRAWINGS SHEET 6 OF 7	DRAWN: BALAMURUGAN/S CUNHA ENGINEER: C FLY	02-DEC-14 02-DEC-14
	APPROVED: B SHERIDAN	02-DEC-14 N.A.

APC Symmetra® PX 250K and 500K UPS Frame Site Planning Data - w/o MBPwD

UPS Module Rating				Mains Input-Single or Dual Feed (Q1) ¹				Static Bypass Input - Dual Feed (Q5) ²				External Battery System ^{3, 6, 14}				AC Output (Q2) ²				Mechanical Data ^{5, 11}							
				Voltage		Current		Recommendations		Currents		Recommendations ⁴		Nominal VDC	Battery kW	Current @ Nom. VDC	Recommendations		Current		Recommendations		Typical Dimensions	Average Weight	Floor Loading	Heat Rejection Battery Fully Charged BTU/HR	Heat Rejection Battery Charging BTU/HR
UPS Frame Rating	Qty of 25kW Power Modules	kVA	kW	Input ¹	Output ²	Full Load	Max. ⁷	100% OCPD	100% Cable	NOM.	Max. ⁵	100% OCPD	100% Cable				100% OCPD	100% Cable	NOM.	Max. ⁸	100% OCPD	100% Cable					
250kVA/250kW 1x 250K Frame	4	100	100	415	415	160	179			139	174			2x 288	104	181			139	174							
	5	125	125	415	415	200	223			174	217			2x 288	130	226			174	217							
	6	150	150	415	415	240	268			209	261			2x 288	156	271			209	261							
	7	175	175	415	415	280	313			243	304			2x 288	182	316			243	304							
	8	200	200	415	415	320	357			278	348			2x 288	208	362			278	348							
	9	225	225	415	415	360	402			313	391			2x 288	234	407			313	391							
500kVA/500kW 2x 250K Frame	10	250	250	415	415	401	447	450A	2x 4/0	348	435	350A	2x 2/0	2x 288	260	452	500A	2x 4/0	348	435	350A	1x 500	47x79x42	2,330	170	35,542	42,759
	11	275	275	415	415	441	491			383	478			2x 288	286	497			383	478							
	12	300	300	415	415	481	536			417	522			2x 288	312	543			417	522							
	13	325	325	415	415	521	581			452	565			2x 288	339	588			452	565							
	14	350	350	415	415	561	626			487	609			2x 288	365	633			487	609							
	15	375	375	415	415	601	670			522	652			2x 288	391	678			522	652							
	16	400	400	415	415	641	715			556	696			2x 288	417	723			556	696							
	17	425	425	415	415	681	760			591	739			2x 288	443	769			591	739							
	18	450	450	415	415	721	804			626	783			2x 288	469	814			626	783							
	19	475	475	415	415	761	849			661	826			2x 288	495	859			661	826							
	20	500	500	415	415	801	894	1000A	3x 400	696	870	700A	3x 250	2x 288	521	904	1000A	3x 400	696	870	700A	2x 500	71x79x42	3,797	183	71,083	85,517

APC Symmetra® PX 250K and 500K UPS Parallel SWBD Site Planning Data ¹⁵

UPS Rating				Mains AC Input Single or Dual Feed (MIB) ¹				Bypass AC Input - Dual Feed (BIB - Q3) ²				AC Output (Q4 - LBB) ²				Mechanical Data ^{5, 11}										
				Voltage		Current		Recommendations ³		Currents		Recommendations		Current		Recommendations		Typical Dimensions	Average Weight	Floor Loading	Heat Rejection Battery Fully Charged BTU/HR	Heat Rejection Battery Charging BTU/HR				
UPS Frame Rating	Qty in Parallel	kVA	kW	Input ¹	Output ²	Full Load	Max. ⁷	100% OCPD	100% Cable	NOM.	Max. ⁵	100% OCPD	100% Cable	NOM.	Max. ⁸	100% OCPD	100% Cable						WxHxD	Lbs	Lbs/Ft2	
250kVA 250kW	2	500	500	415	415	801	894	1000A	3x 400	696	870	700A	2x 500			696	870	700A	2x 350						71,083	85,517
	3	750	750	415	415	1202	1341	1600A	4x 600	1044	1305	1200A	3x 600			1044	1305	1200A	3x 600						1,06,626	1,28,276
	4	1000	1000	415	415	1602	1788	2000A	5x 600	1392	1740	1600A	4x 600			1392	1740	1600A	4x 600						1,42,166	1,71,034
500kVA 500kW	2	1000	1000	415	415	1602	1788	2000A	5x 600	1392	1740	1600A	4x 600			1392	1740	1600A	4x 600						142,166	1,71,034
	3	1500	1500	415	415	2403	2682	3000A	8x 500	2088	2610	2500A	6x 600			2088	2610	2500A	6x 600						2,13,249	2,56,551
	4	2000	2000	415	415	3204	3576	4000A	10x 600	2784	3480	3000A	8x 500			2784	3480	3000A	8x 500						2,84,332	3,42,068

APC Symmetra® PX

Notes.

- Mains Input source must be 415Y/240V 4-wire + Ground for single feed or 3-wire + Ground for dual feed. Contact Schneider Electric if other.
- Output is 415Y/240V 4-wire + GROUND. The bypass AC input source must be 415Y/240V 4-wire + ground..
- Recommended cables are AWG/kcmil minimum requirement for three (3) current carrying conductors in raceway, sized for 30°C environment and 75°C terminations. All cabling must comply with installation site conditions and any applicable Local and or Natio
- Dual Feed static bypass input feeder is limited to maximum size of 250kcmil conductor.
- Mechanical Data is approximate and does not include the battery system or maintenance bypass switchgear or external DC Disconnects. For precise mechanical data on your planned system configuration contact Schneider Electric.
- Contact Schneider Electric for assistance with all external battery designs. Maximum allowed DC cabling voltage drop is 1 VDC. Schneider Electric Standard external DCD's are rated 500A (PX 250kVA) or 1000A (PX 500kVA).
- Electronic Input Current Limit.
- This is the UPS short time rating of 125% Overload for 10 minutes. Actual short time performance may be limited by the over current protective device selected.
- For maximum scalability or future expansion it is recommended that the UPS frames be installed at their full ratings - see green highlighted data.
- All OCPD's and cabling are by others.
- Heat rejection calculations are based on watt to BTU/HR conversion factor of 1 watt = 3.412 BTU/HR.
- Not Applicable - Maximum input OCPD rating is 1000A.
- OCPD = Over Current Protective Device
- Common battery system is not allowed or supported for this product
- See applicable submittal drawings for additional details.

1500kVA/kW (500kW 3 MODULE CAPACITY) SINGLE/DUAL INPUT TOP/BOTTOM FEED 4WIRE OUTPUT CONFIGURATION

THIS DRAWING AND SPECIFICATIONS HEREIN ARE THE PROPERTY OF SCHNEIDER ELECTRIC AND SHALL NOT BE COPIED, REPRODUCED OR USED IN WHOLE OR IN PART, AS THE BASIS FOR THE MANUFACTURE OR SALE OF ITEMS WITHOUT WRITTEN PERMISSION FROM SCHNEIDER ELECTRIC. THIS DRAWING IS BASED UPON LATEST AVAILABLE INFORMATION AND IS SUBJECT TO CHANGE WITHOUT NOTICE.



TITLE: SYMMETRA PX
INPUT: 415V 3φ, DUAL & SINGLE MAINS
OUTPUT: 1500kVA/kW 415V 3φ
500kW 3 MOD N TOP FEED W/LINE-UP BATTERIES
SITE PLANNING DATA

PROJECT: SUBMITTAL DRAWINGS | SHEET 4 OF 4

DWG NO: SY500K1500HC3-4W-SD REV. 0
DRAWN: BALAMURUGAN/V BUSH 20-MAY-11
ENGINEER: A WARNER/C BARBOZA 28-JUL-11
APPROVED: B SHERIDAN/S VOOCD/M DESHPANDE 28-JUL-11
PROJ ANGLE N.A.