
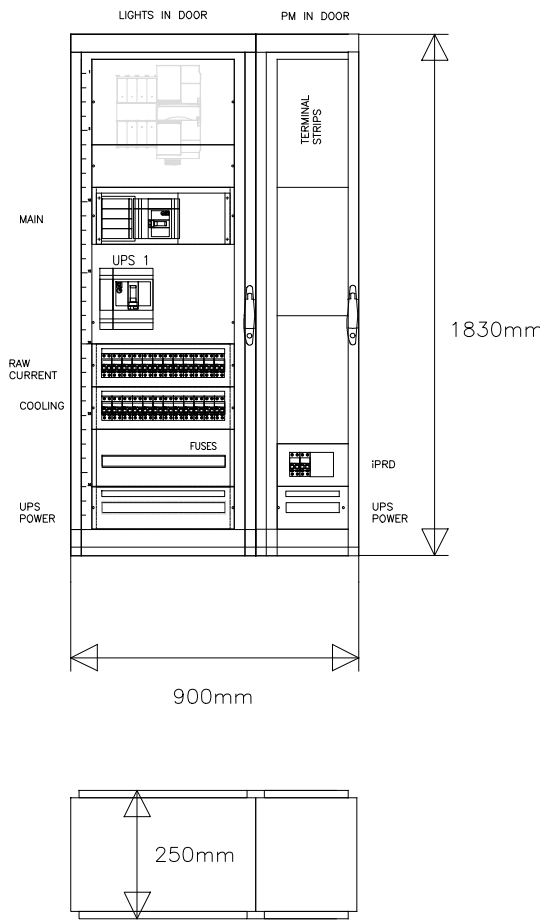


THIS DRAWING AND SPECIFICATIONS ARE THE PROPERTY OF SCHNEIDER ELECTRIC AND SHALL NOT BE COPIED, REPRODUCED OR USED IN WHOLE OR IN PART, AS THE BASIS FOR THE MANUFACTURE OR SALE OF ITEMS WITHOUT WRITTEN PERMISSION FROM SCHNEIDER ELECTRIC. THIS DRAWING IS BASED ON LATEST AVAILABLE INFORMATION AND IS SUBJECT TO CHANGE WITHOUT NOTICE.

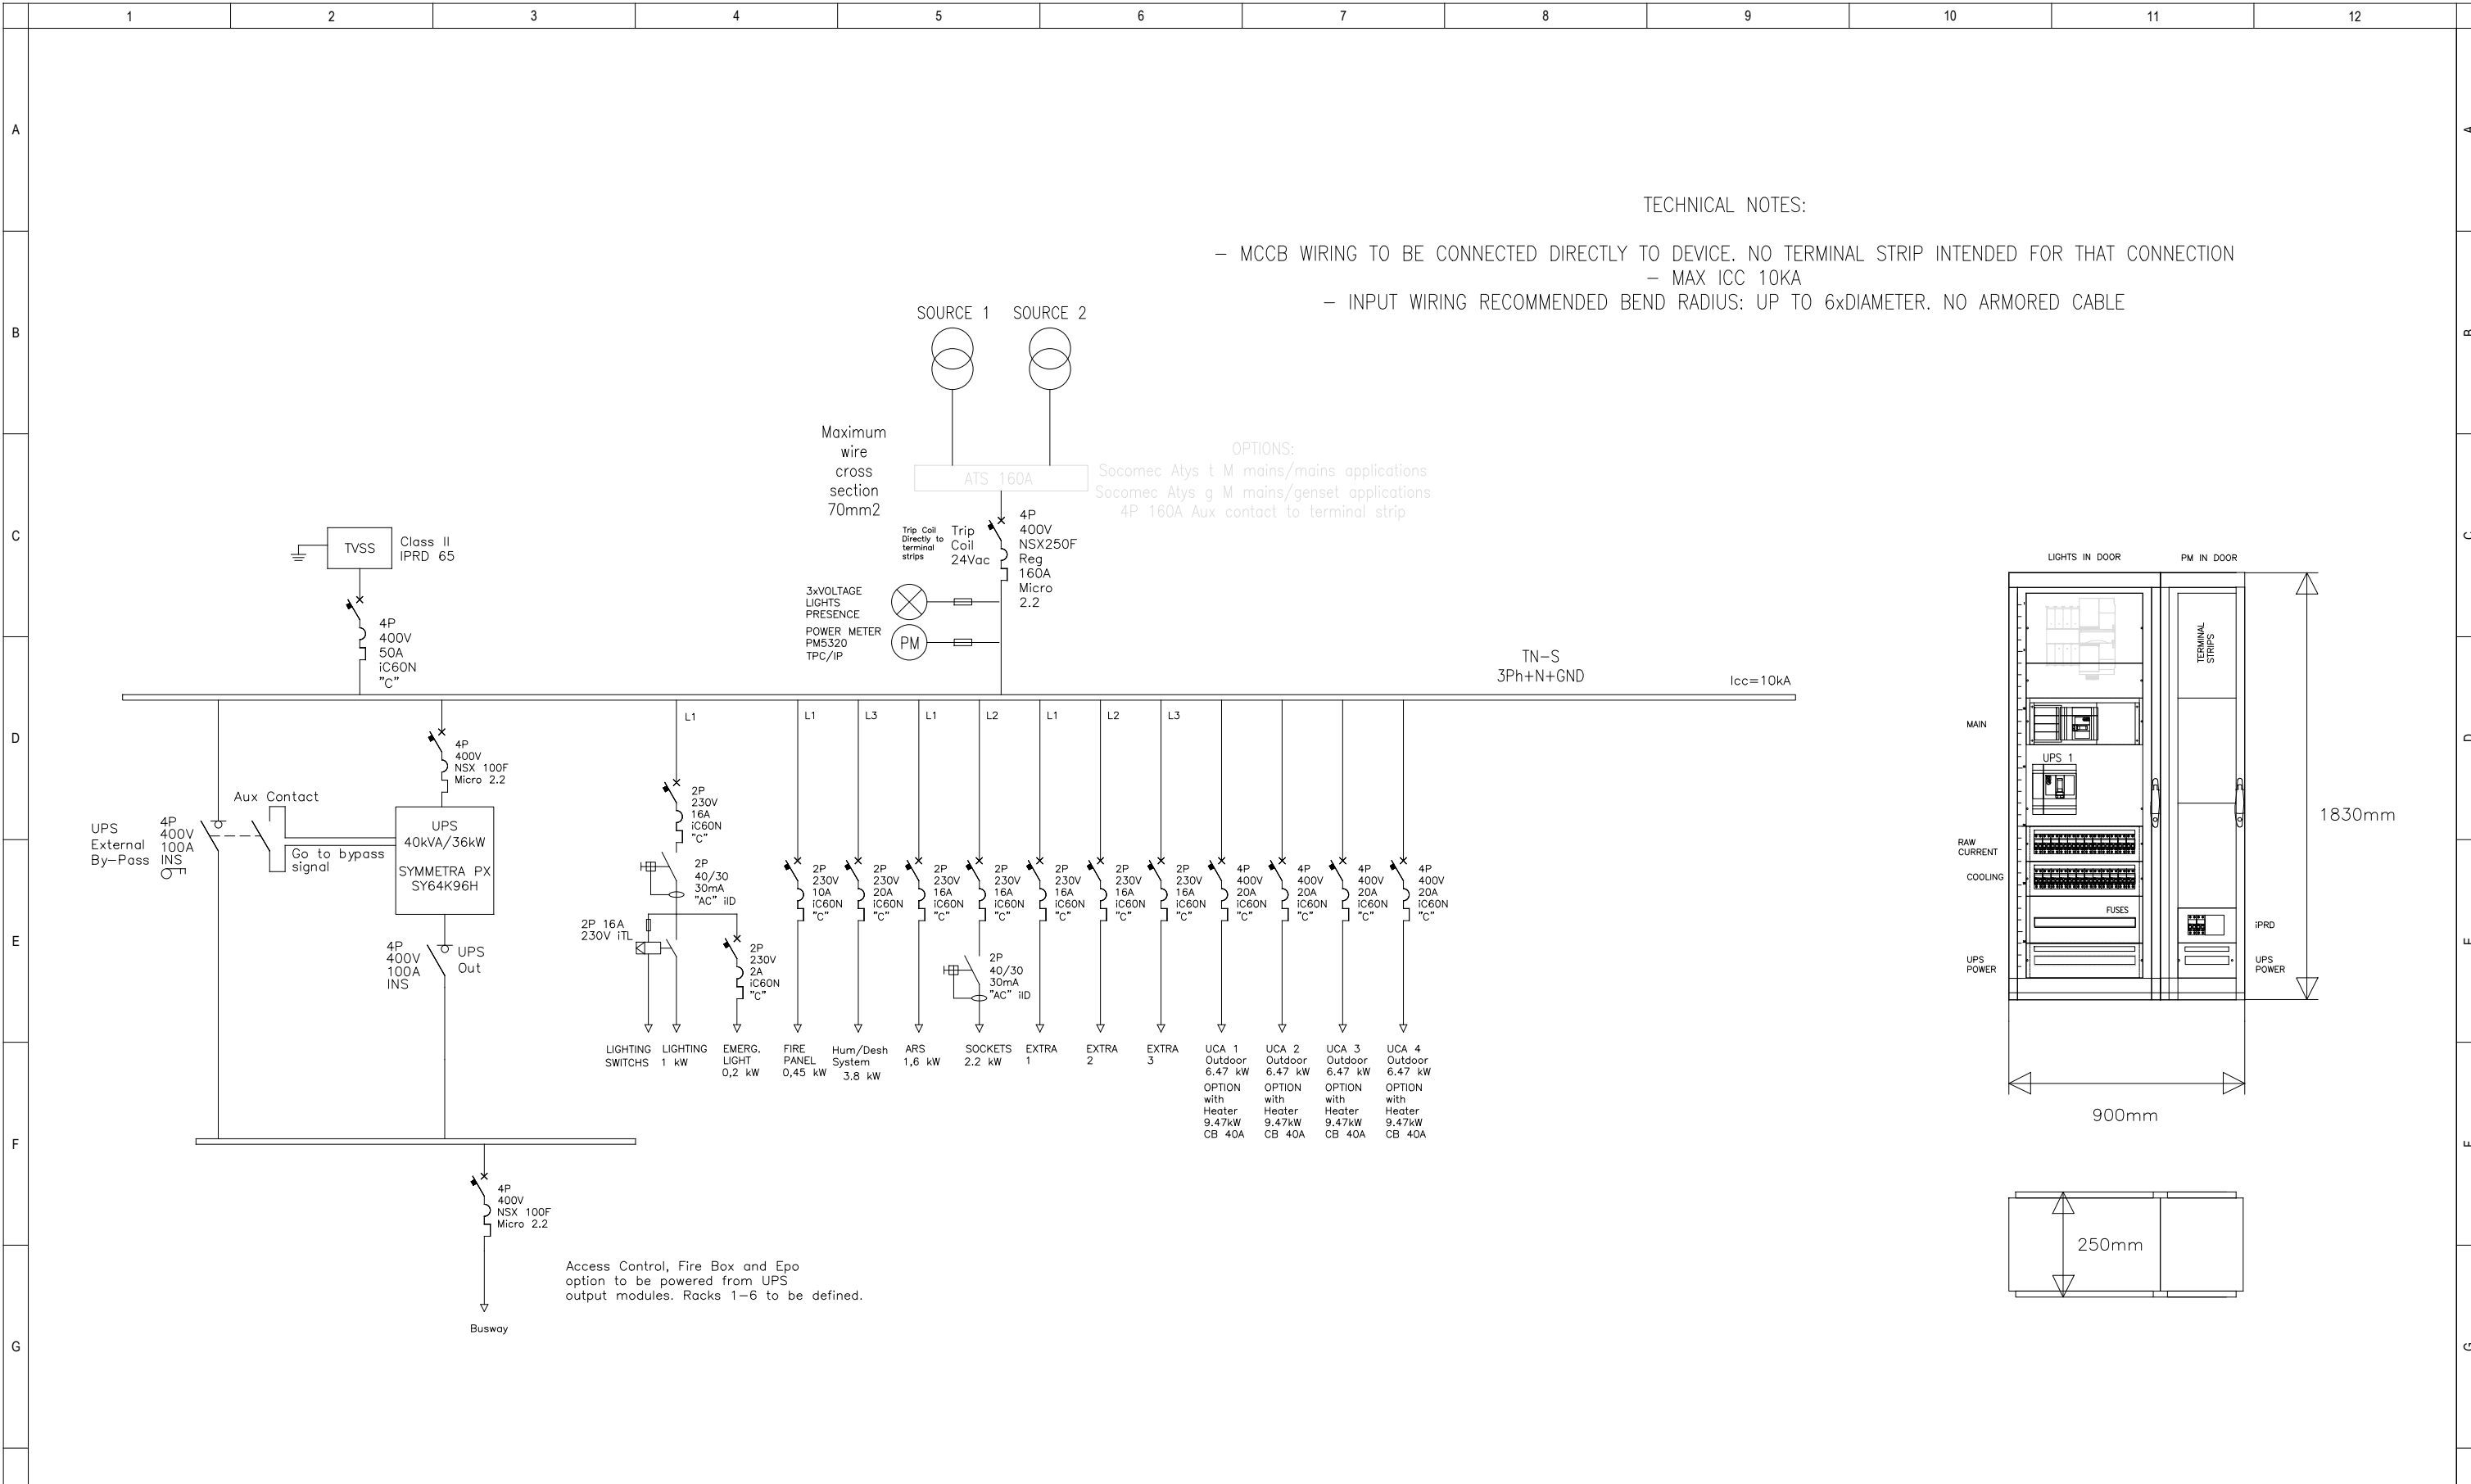

Rev.	Date	Description	Rev.	Date	Description
V2	26-10-16	Drawing update			
V3	02-11-16	UCA power feed update			
V4	25-01-17	Busway with Galaxy option included			

QA System Drawn by DS Designed by DS Check by DS Authorised by DS		C. Coto, 9 08830 Sant Boi de Llobregat Barcelona (Spain) T: +34 934 751 481 F: +34 933 772 880	9701 Windsch Rd, Suite 300 West Chester Township OH 45069-3807 United States T: +1 513 644 0560	Project PFMICJ038F1R05B EMEA Drawing Title ISO 20FT SYMMETRA N+1 UCA ELECTRICAL SINGLE LINE DIAGRAM Project Ref. 000000 Units UNITS Scale Sheet Size A3 Date 08.09.2016	Customer Logo Drawing Code CO01.E02.A01.304
---	--	--	---	--	--