


THIS DRAWING AND SPECIFICATIONS ARE THE PROPERTY OF SCHNEIDER ELECTRIC AND SHALL NOT BE COPIED, REPRODUCED OR USED IN WHOLE OR IN PART, AS THE BASIS FOR THE MANUFACTURE OR SALE OF ITEMS WITHOUT WRITTEN PERMISSION FROM SCHNEIDER ELECTRIC. THIS DRAWING IS BASED ON LATEST AVAILABLE INFORMATION AND IS SUBJECT TO CHANGE WITHOUT NOTICE.

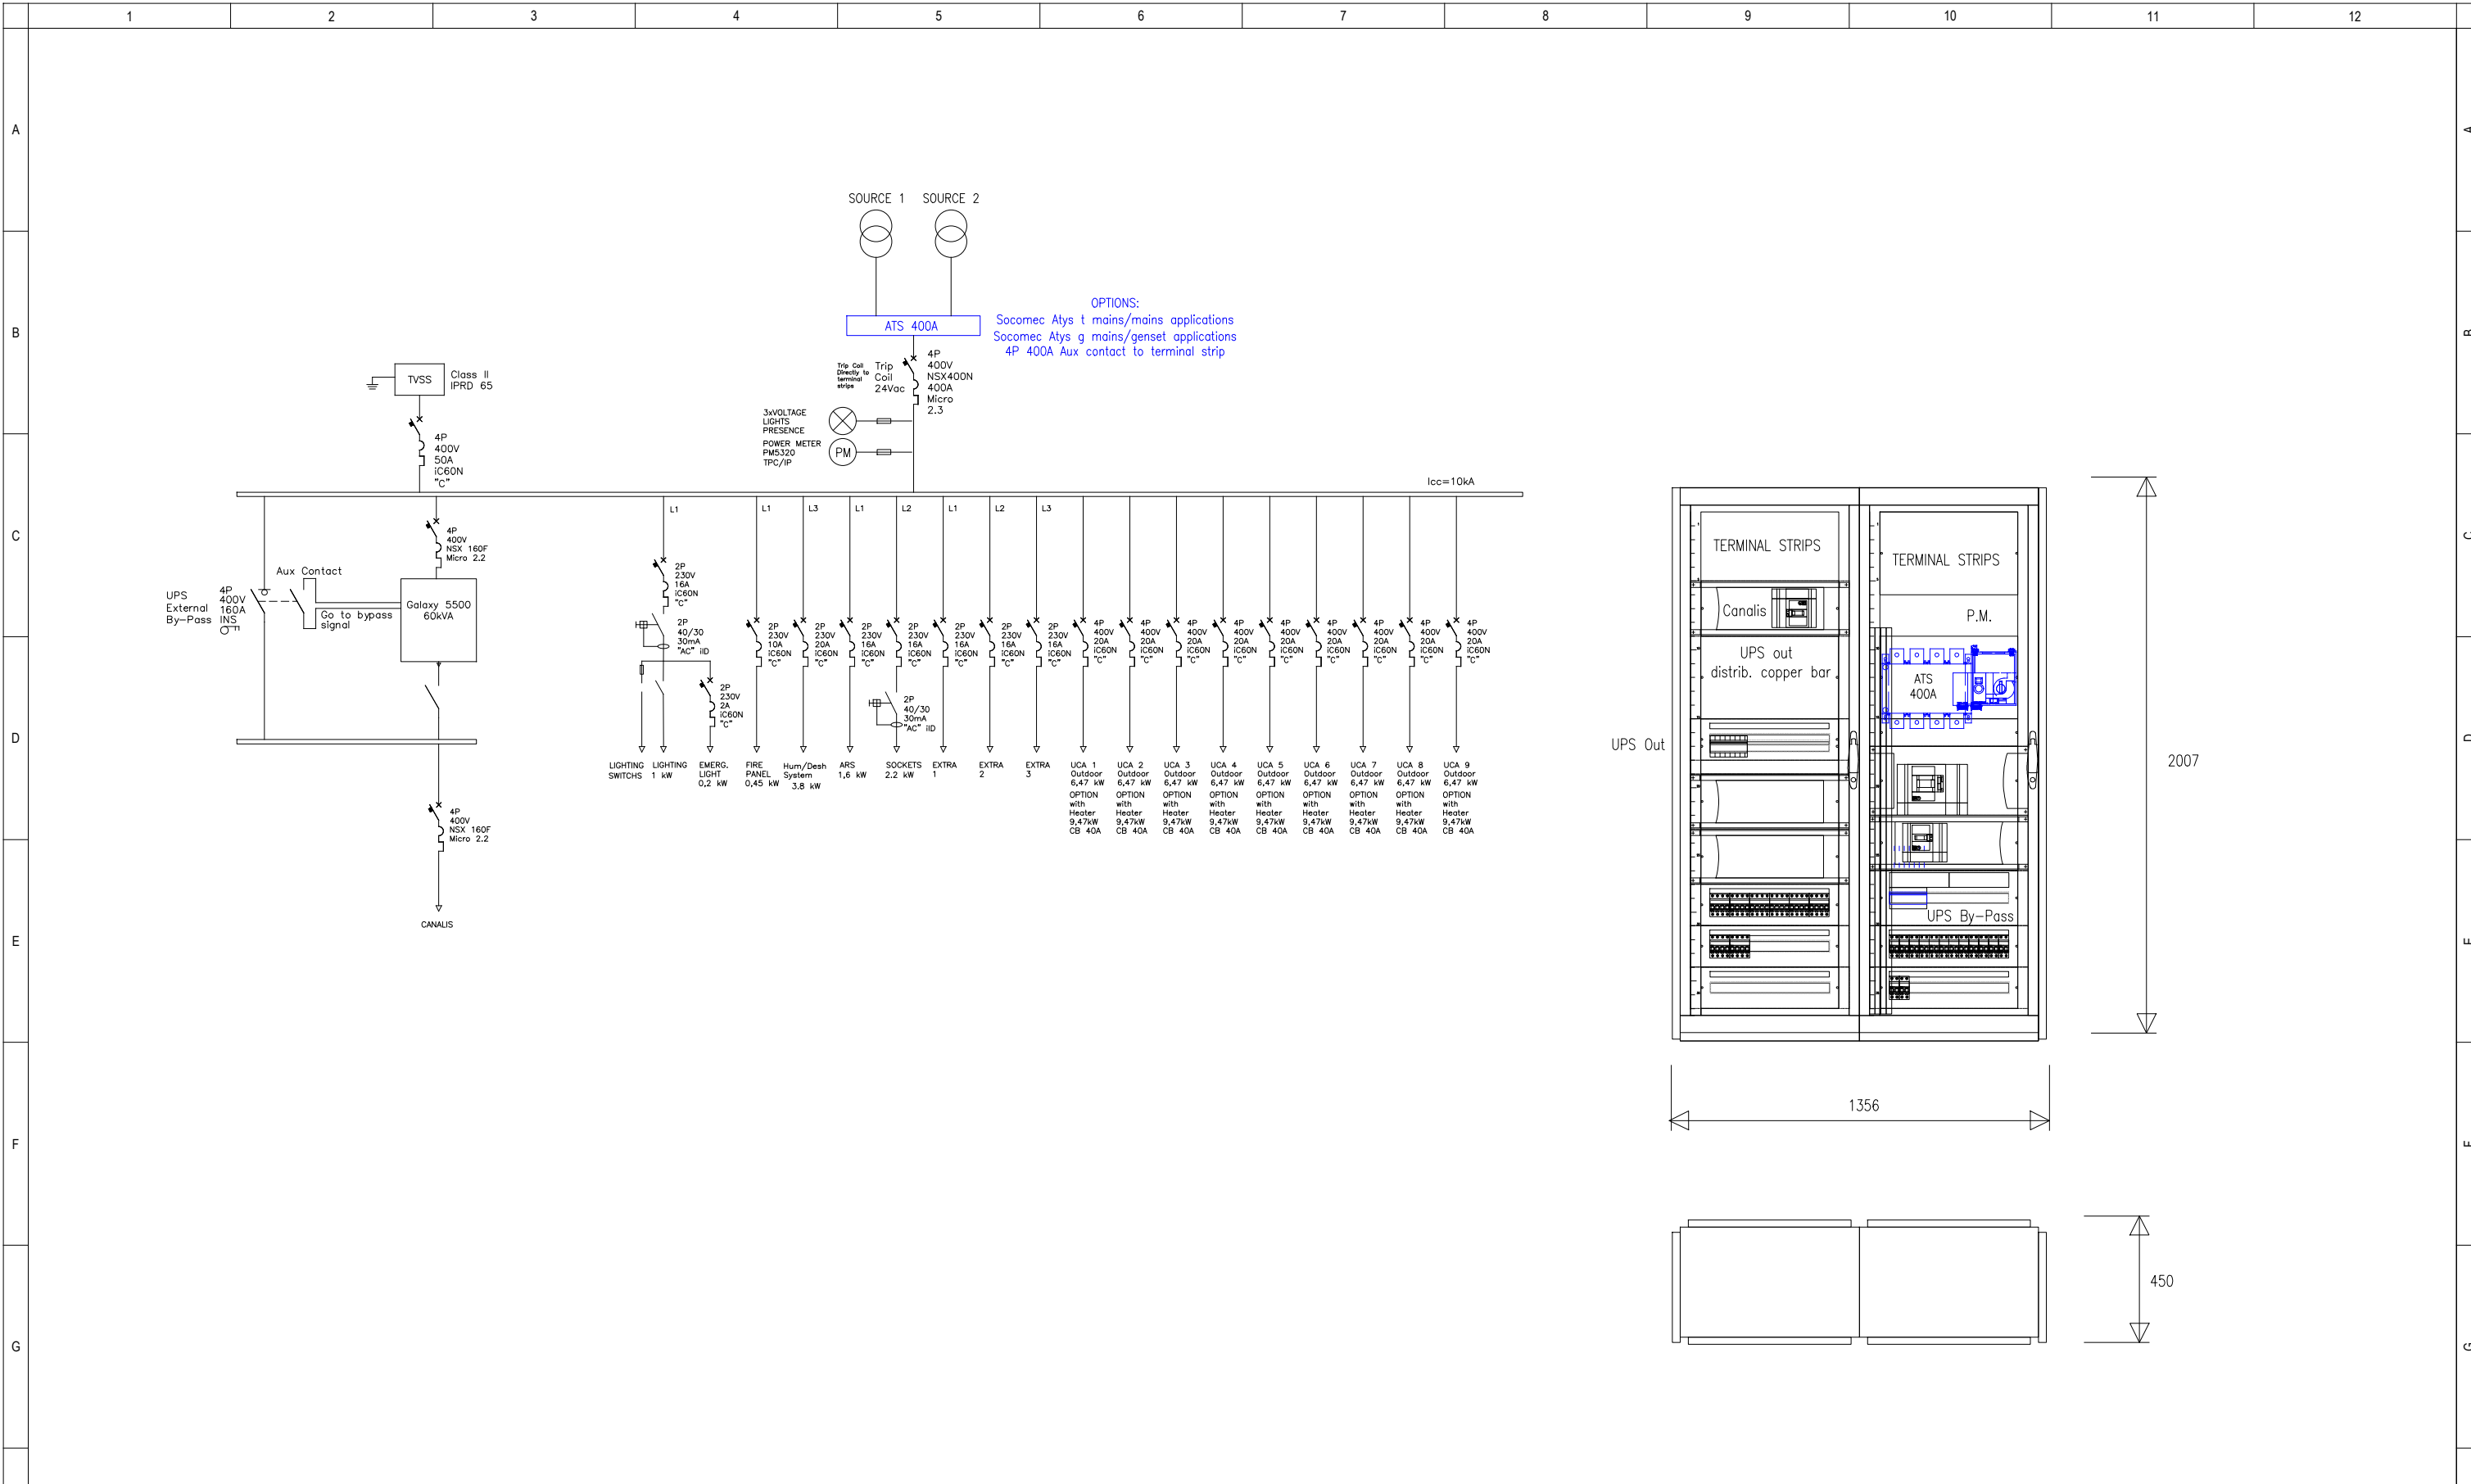

Rev.	Date	Description	Rev.	Date	Description

QA System Drawn by DS Designed by DS Check by DS Authorised by XB	<p>C. Coto, 9 08830 Sant Boi de Llobregat Barcelona (Spain) T: +34 934 751 481 F: +34 933 772 880 www.schneider-electric.com</p>	<p>9701 Windsch Rd, Suite 300 West Chester Township OH 45069-3807 United States T: +1 513 644 0560</p>	<p>Project PFMICJ042F1R12B EMEA</p> <p>Drawing Title ISO 40FT UCA GALAXY ELECTRICAL SINGLE LINE DIAGRAM</p> <p>Project Ref. -----</p>	<p>Customer Logo</p> <p>Drawing Code CO01.E02.A02.300</p> <p>Sheet Size A3</p> <p>Date 01.09.2017</p>
---	--	--	---	---